



CONSTRUCTION ON LOT 11, PIN # 5686-92-1549,
1718 Highland Dr.

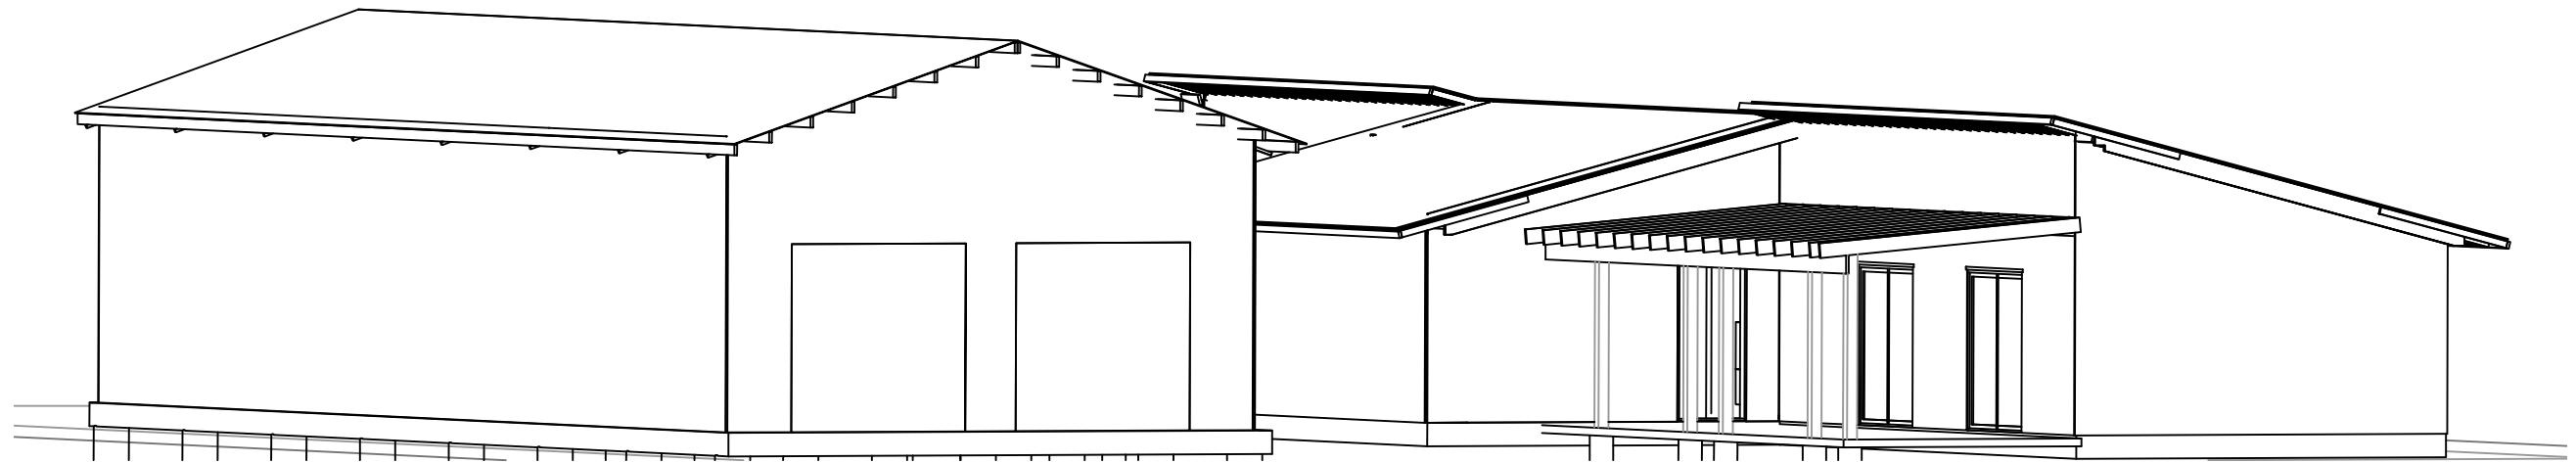


**DESIGN
DESIGN**

1718 HIGHLAND DR
DRAWING NO. TITLE

CONNECTION
TO GARAGE

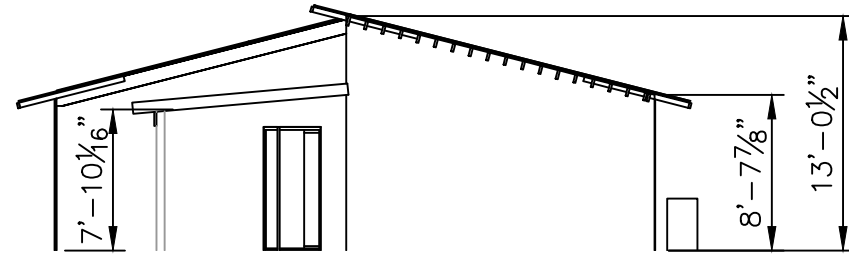


FRONT VIEW
SCALE: 3/32" = 1'-0"

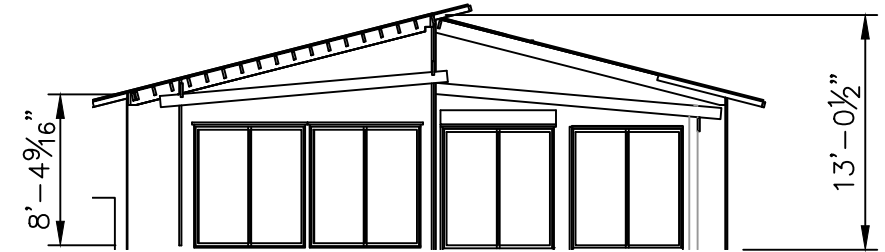

BACK VIEW
SCALE: 3/32" = 1'-0"

HOUSE

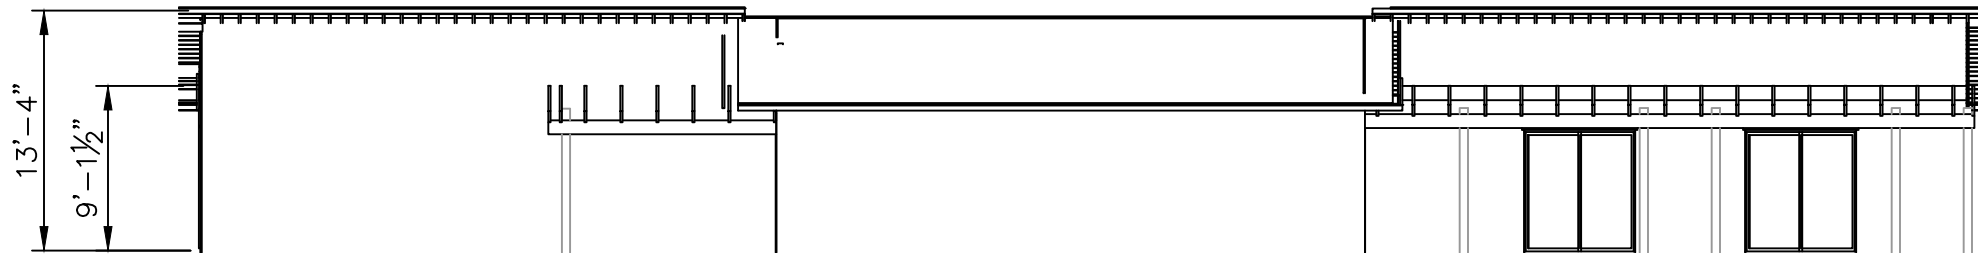


LEFT VIEW
SCALE: 3/32" = 1'-0"


STUDIO

**BEZIGN
DESIGN**


1718 HIGHLAND DR
DRAWING NO. ELEVATIONS

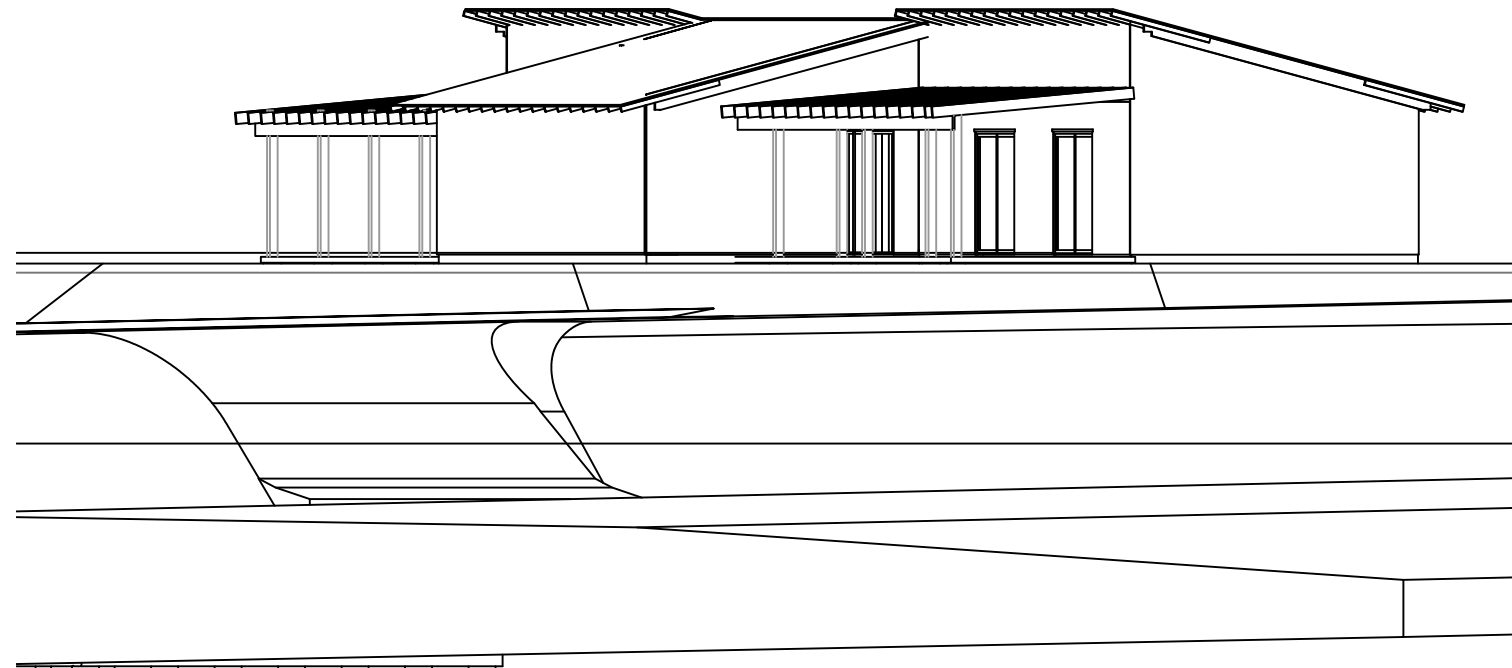

SOUTH EAST VIEW FRONT

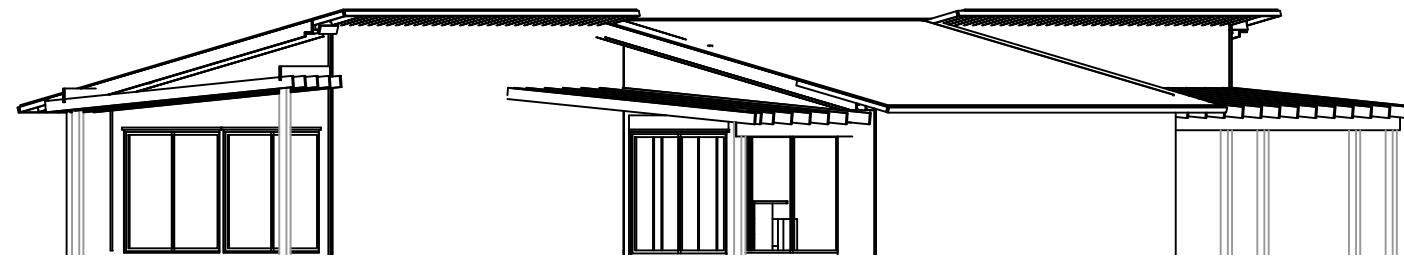


NORTH WEST COURT YARD HOUSE

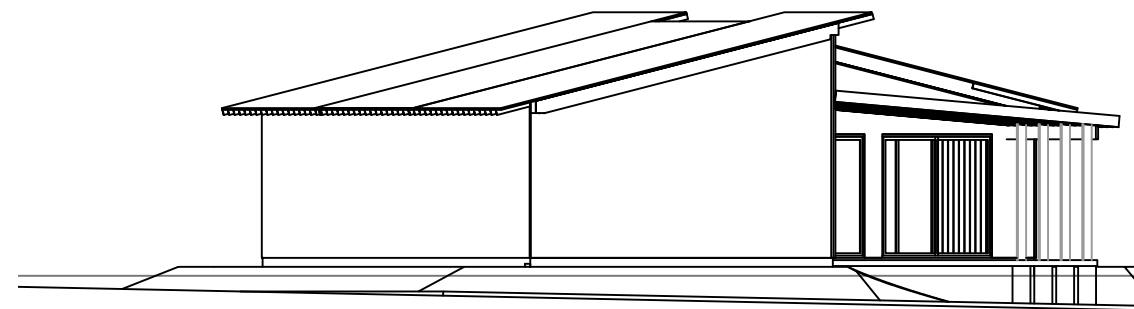

NORTH EAST COURT YARD HOUSE

**REZIGN
DESIGN**

1718 HIGHLAND DR
DRAWING NO. ISOMETRIC

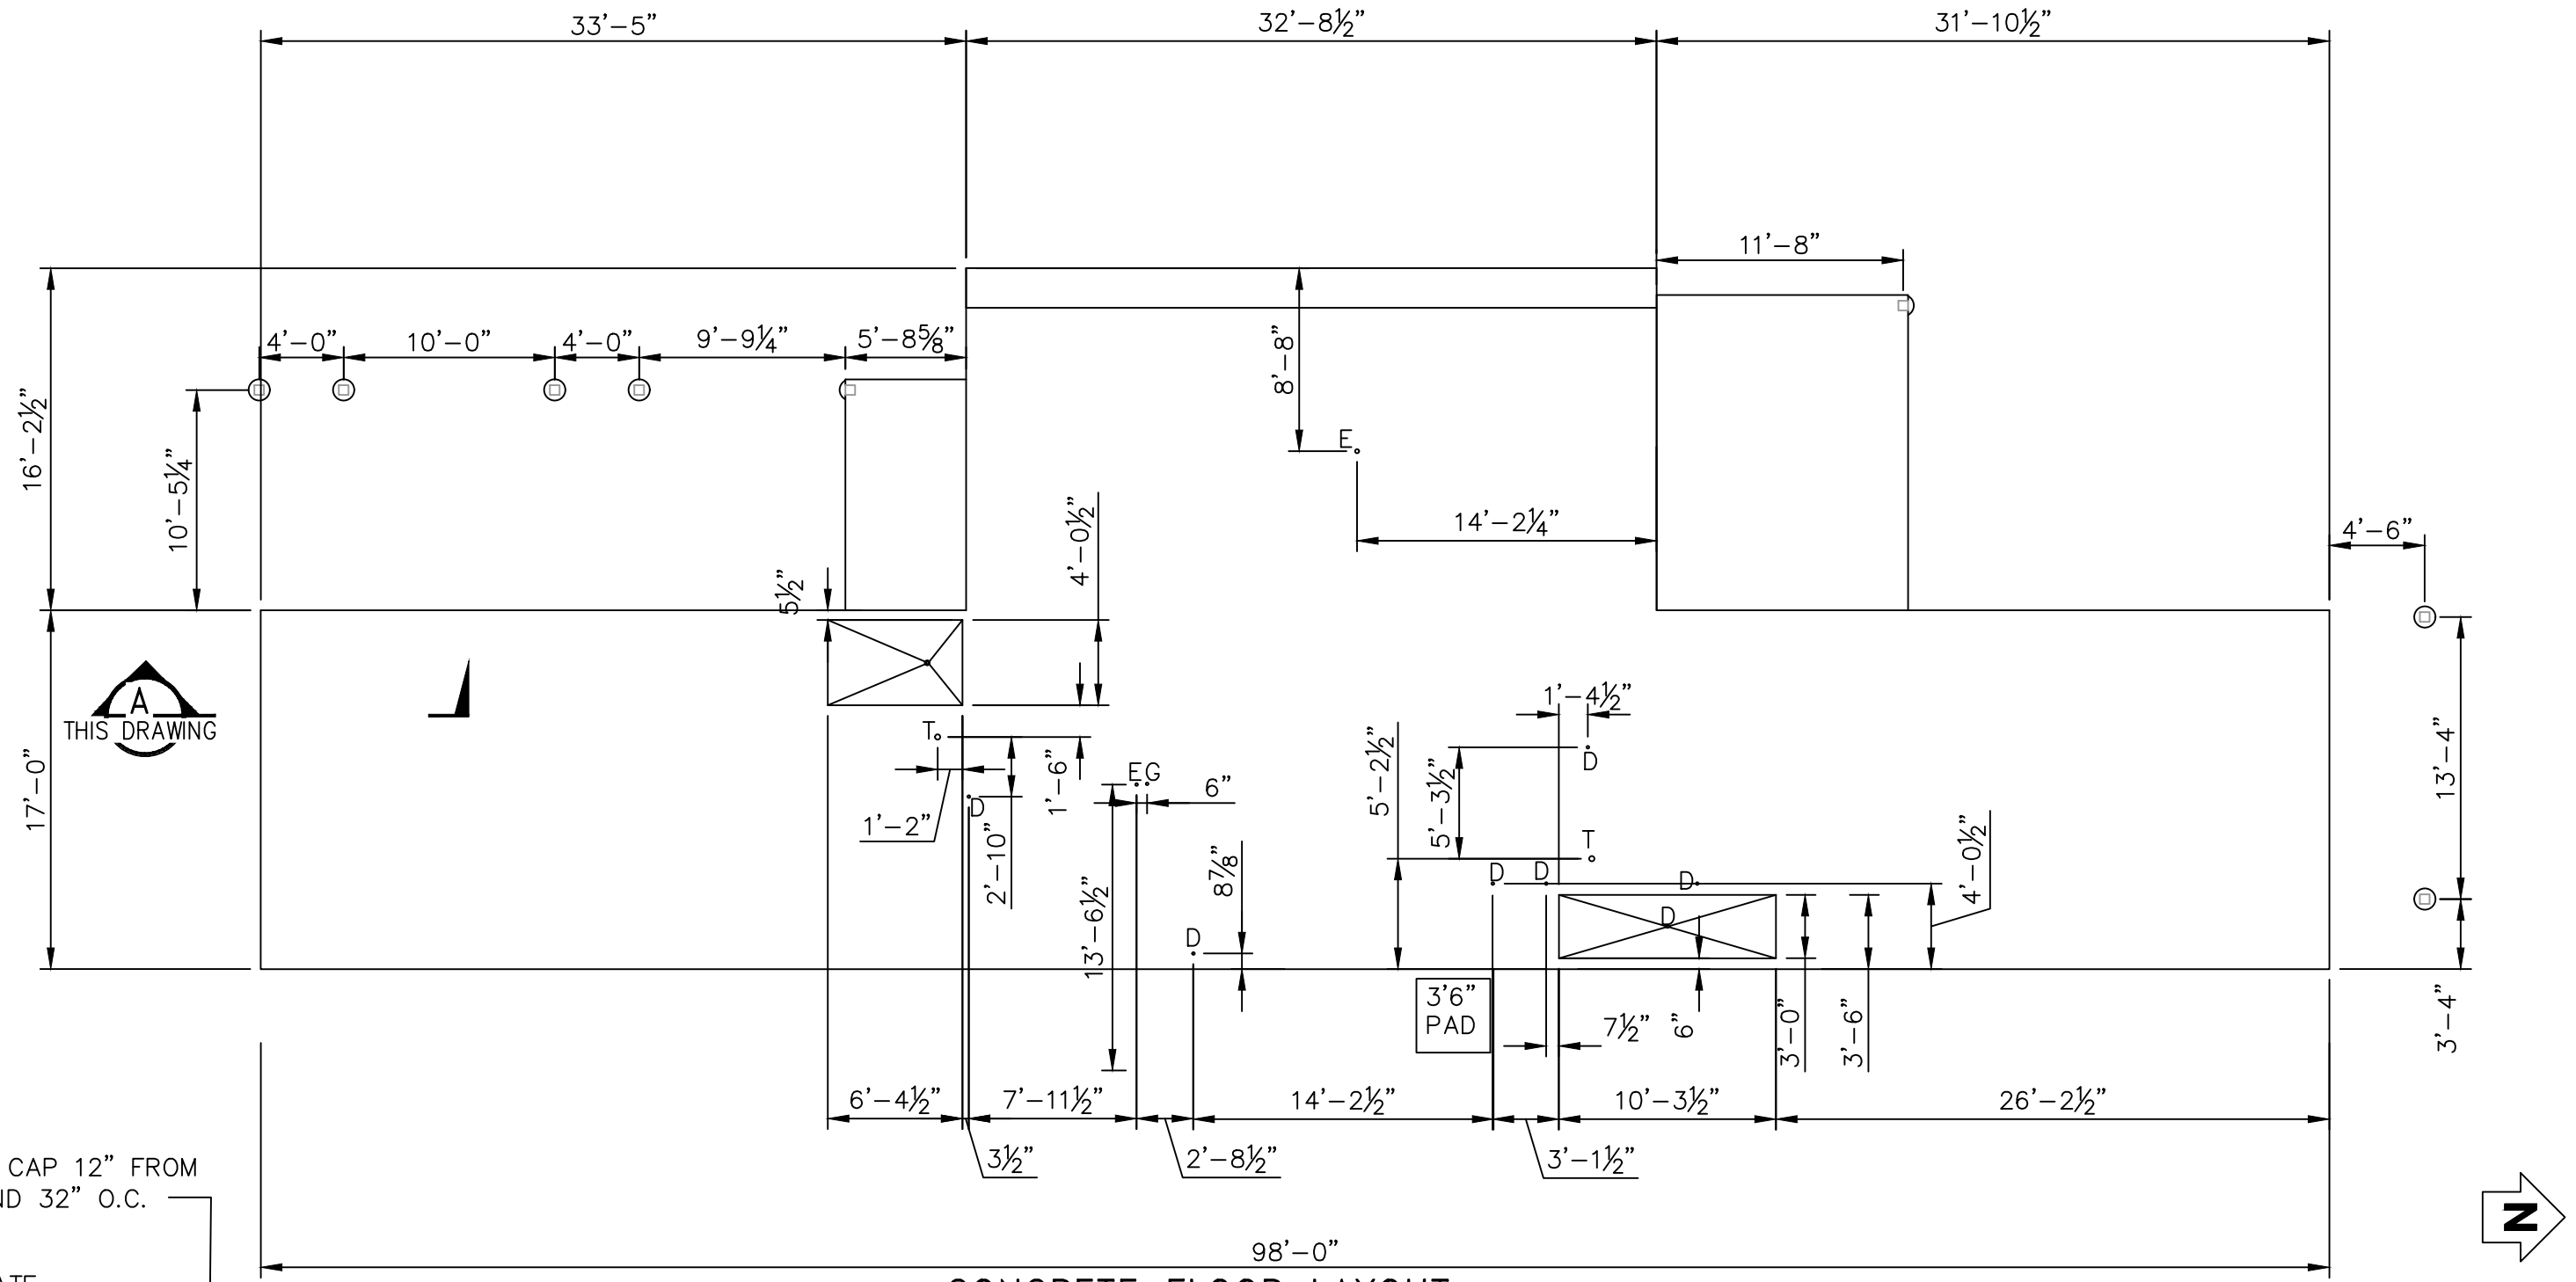


CONCRETE FLOOR LAYOUT

SCALE: 1/4" = 1'-0"

- D=DRAIN
- E=ELECTRICAL
- G=GAS
- T=TIOLET

7/8"x6" RED CAP 12" FROM END (MIN) AND 32" O.C.

3" SQUARE PLATE

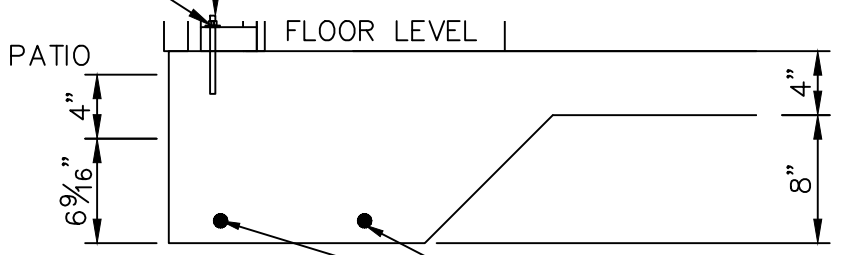


SECTION

SCALE: 1"=1'-0"



1718 HIGHLAND DR

DRAWING NO.
PAD LAYOUT

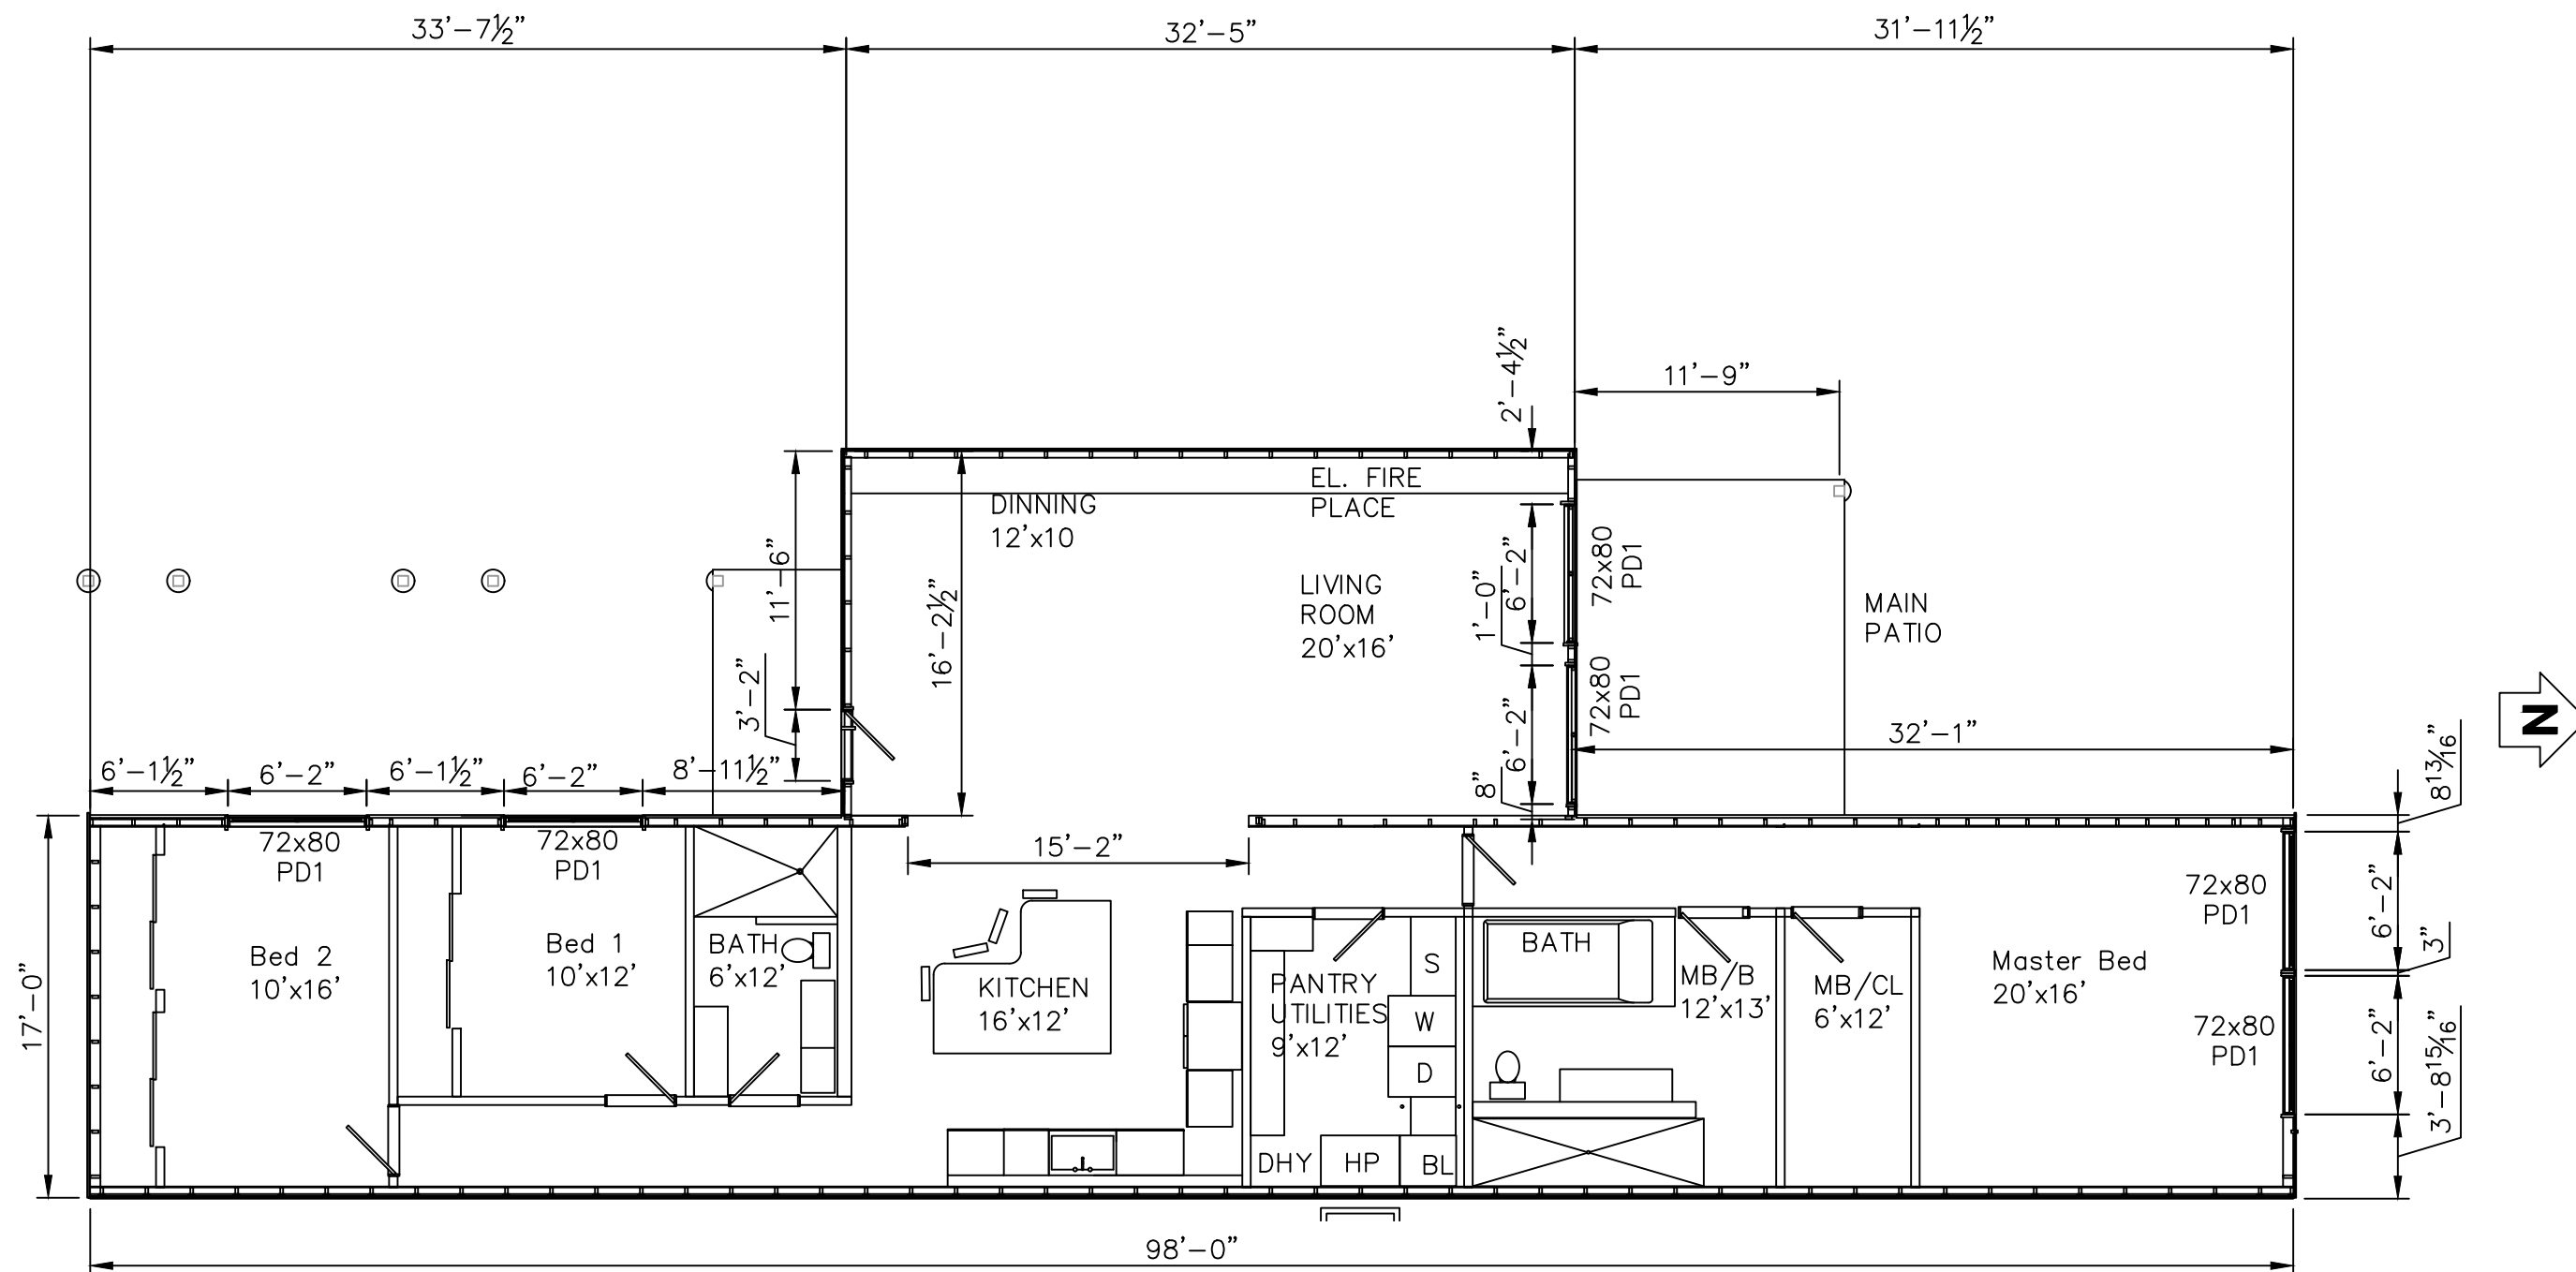


FLOOR PLAN
SCALE: 1/8" = 1'-0"

REZIGN DESIGN

1718 HIGHLAND DR

DRAWING NO.
PLAN

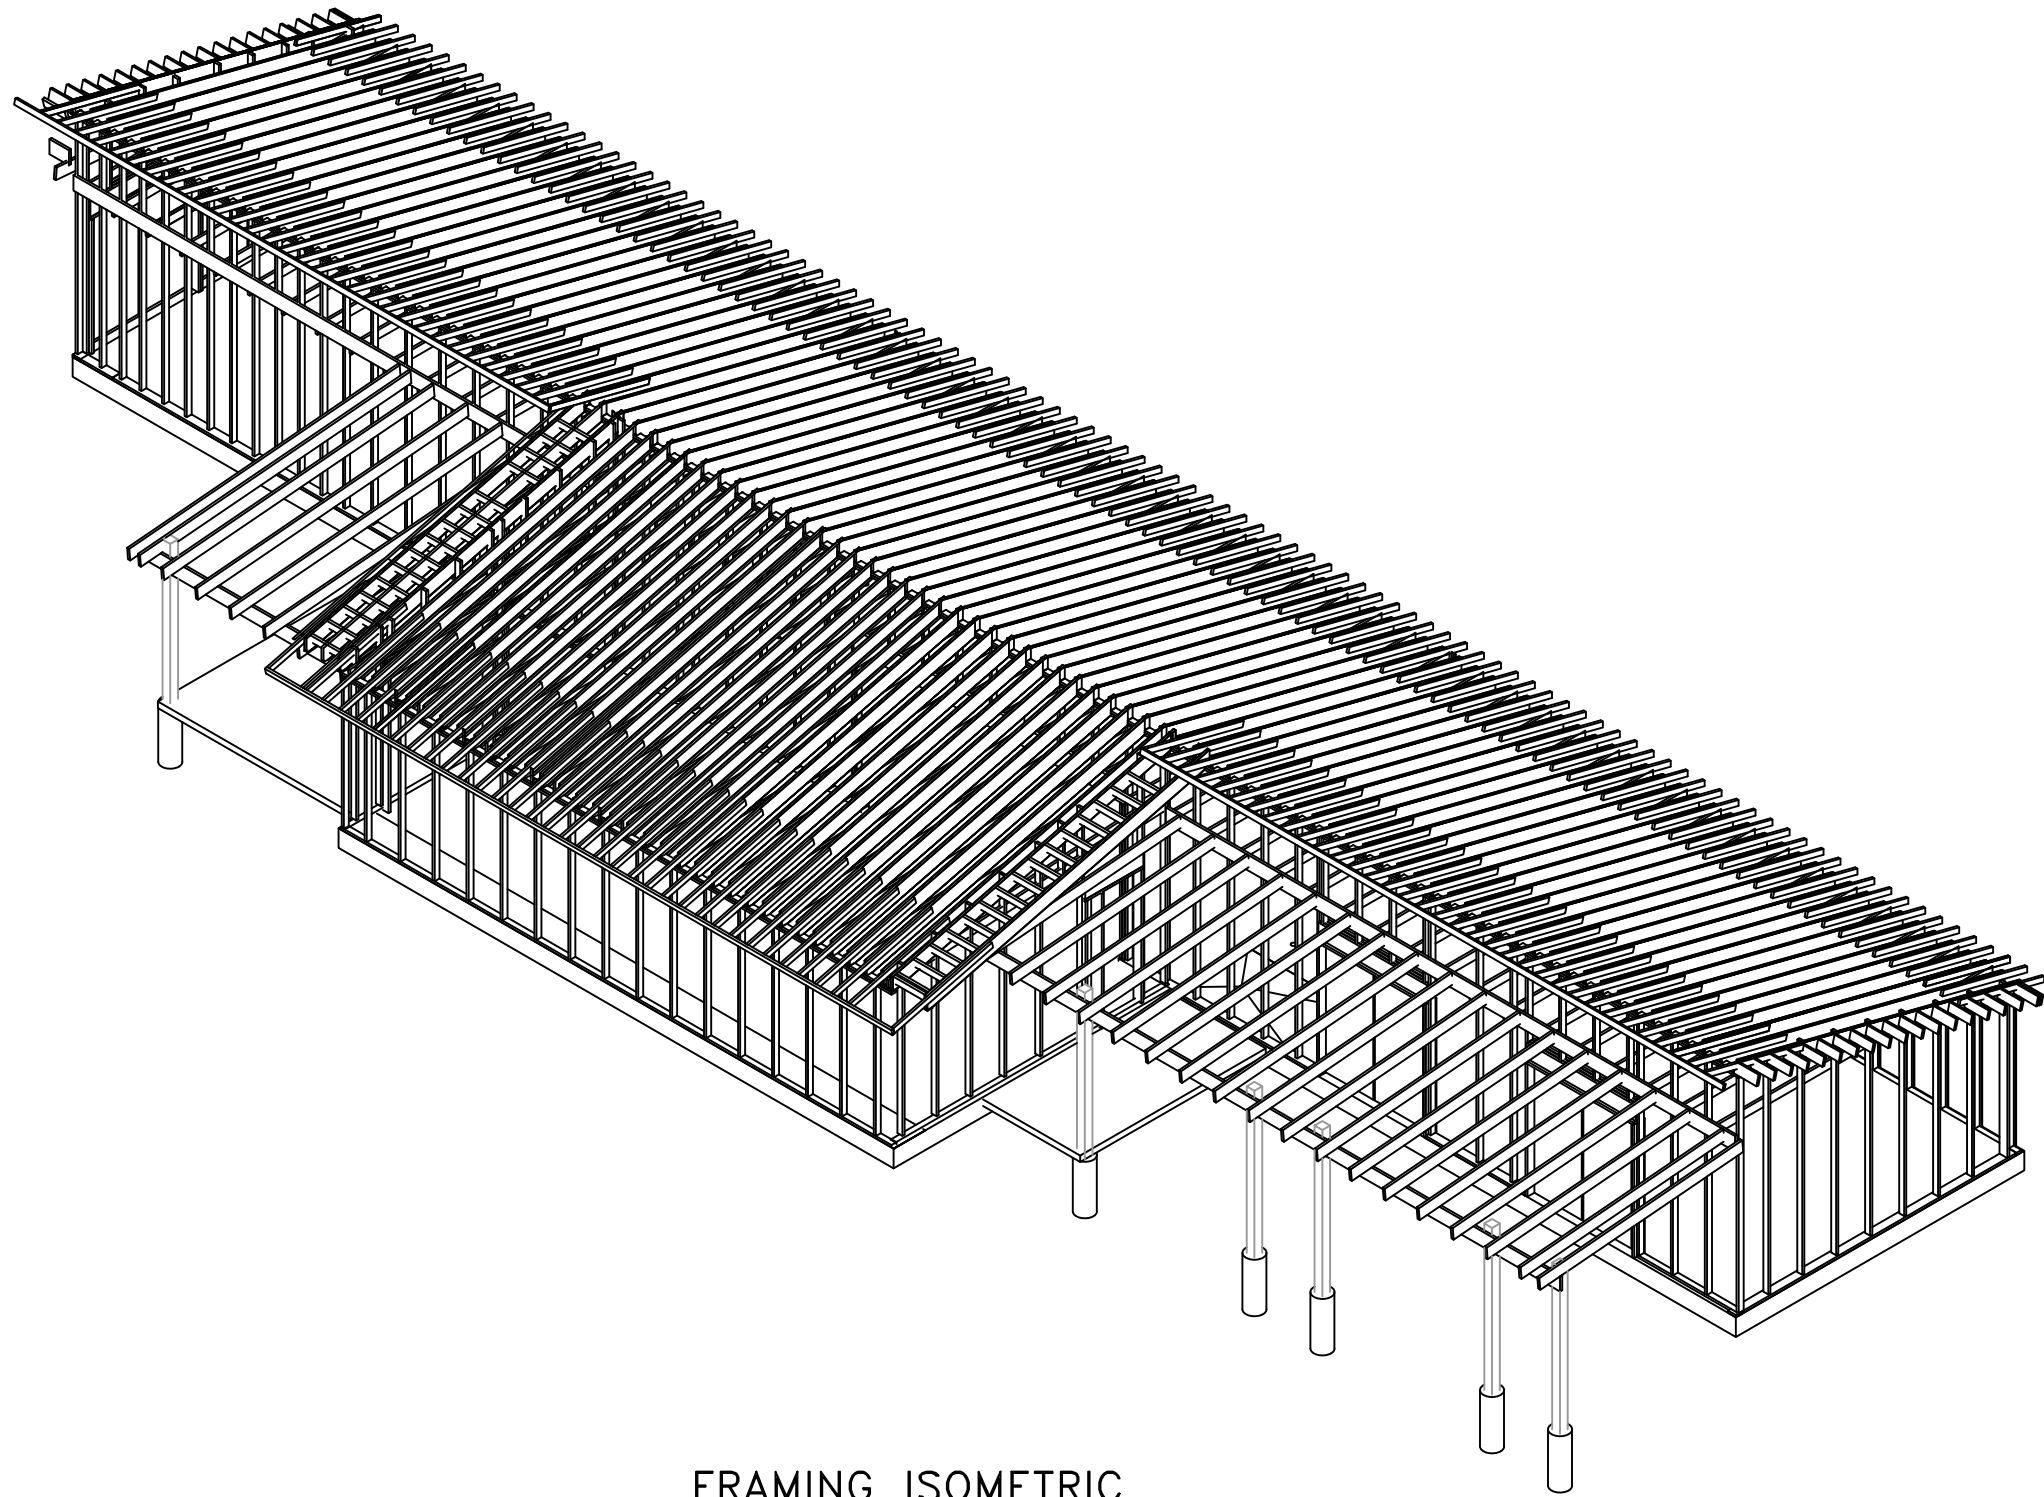



FRAMING ISOMETRIC

SCALE: 1/8" = 1'-0"

**REZIGN
DESIGN**

1718 HIGHLAND DR



DRAWING NO.
FRAMING ISO

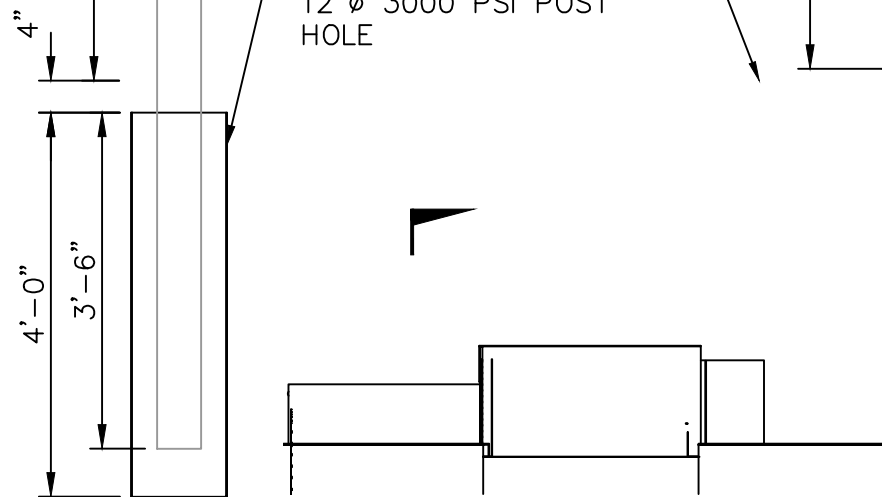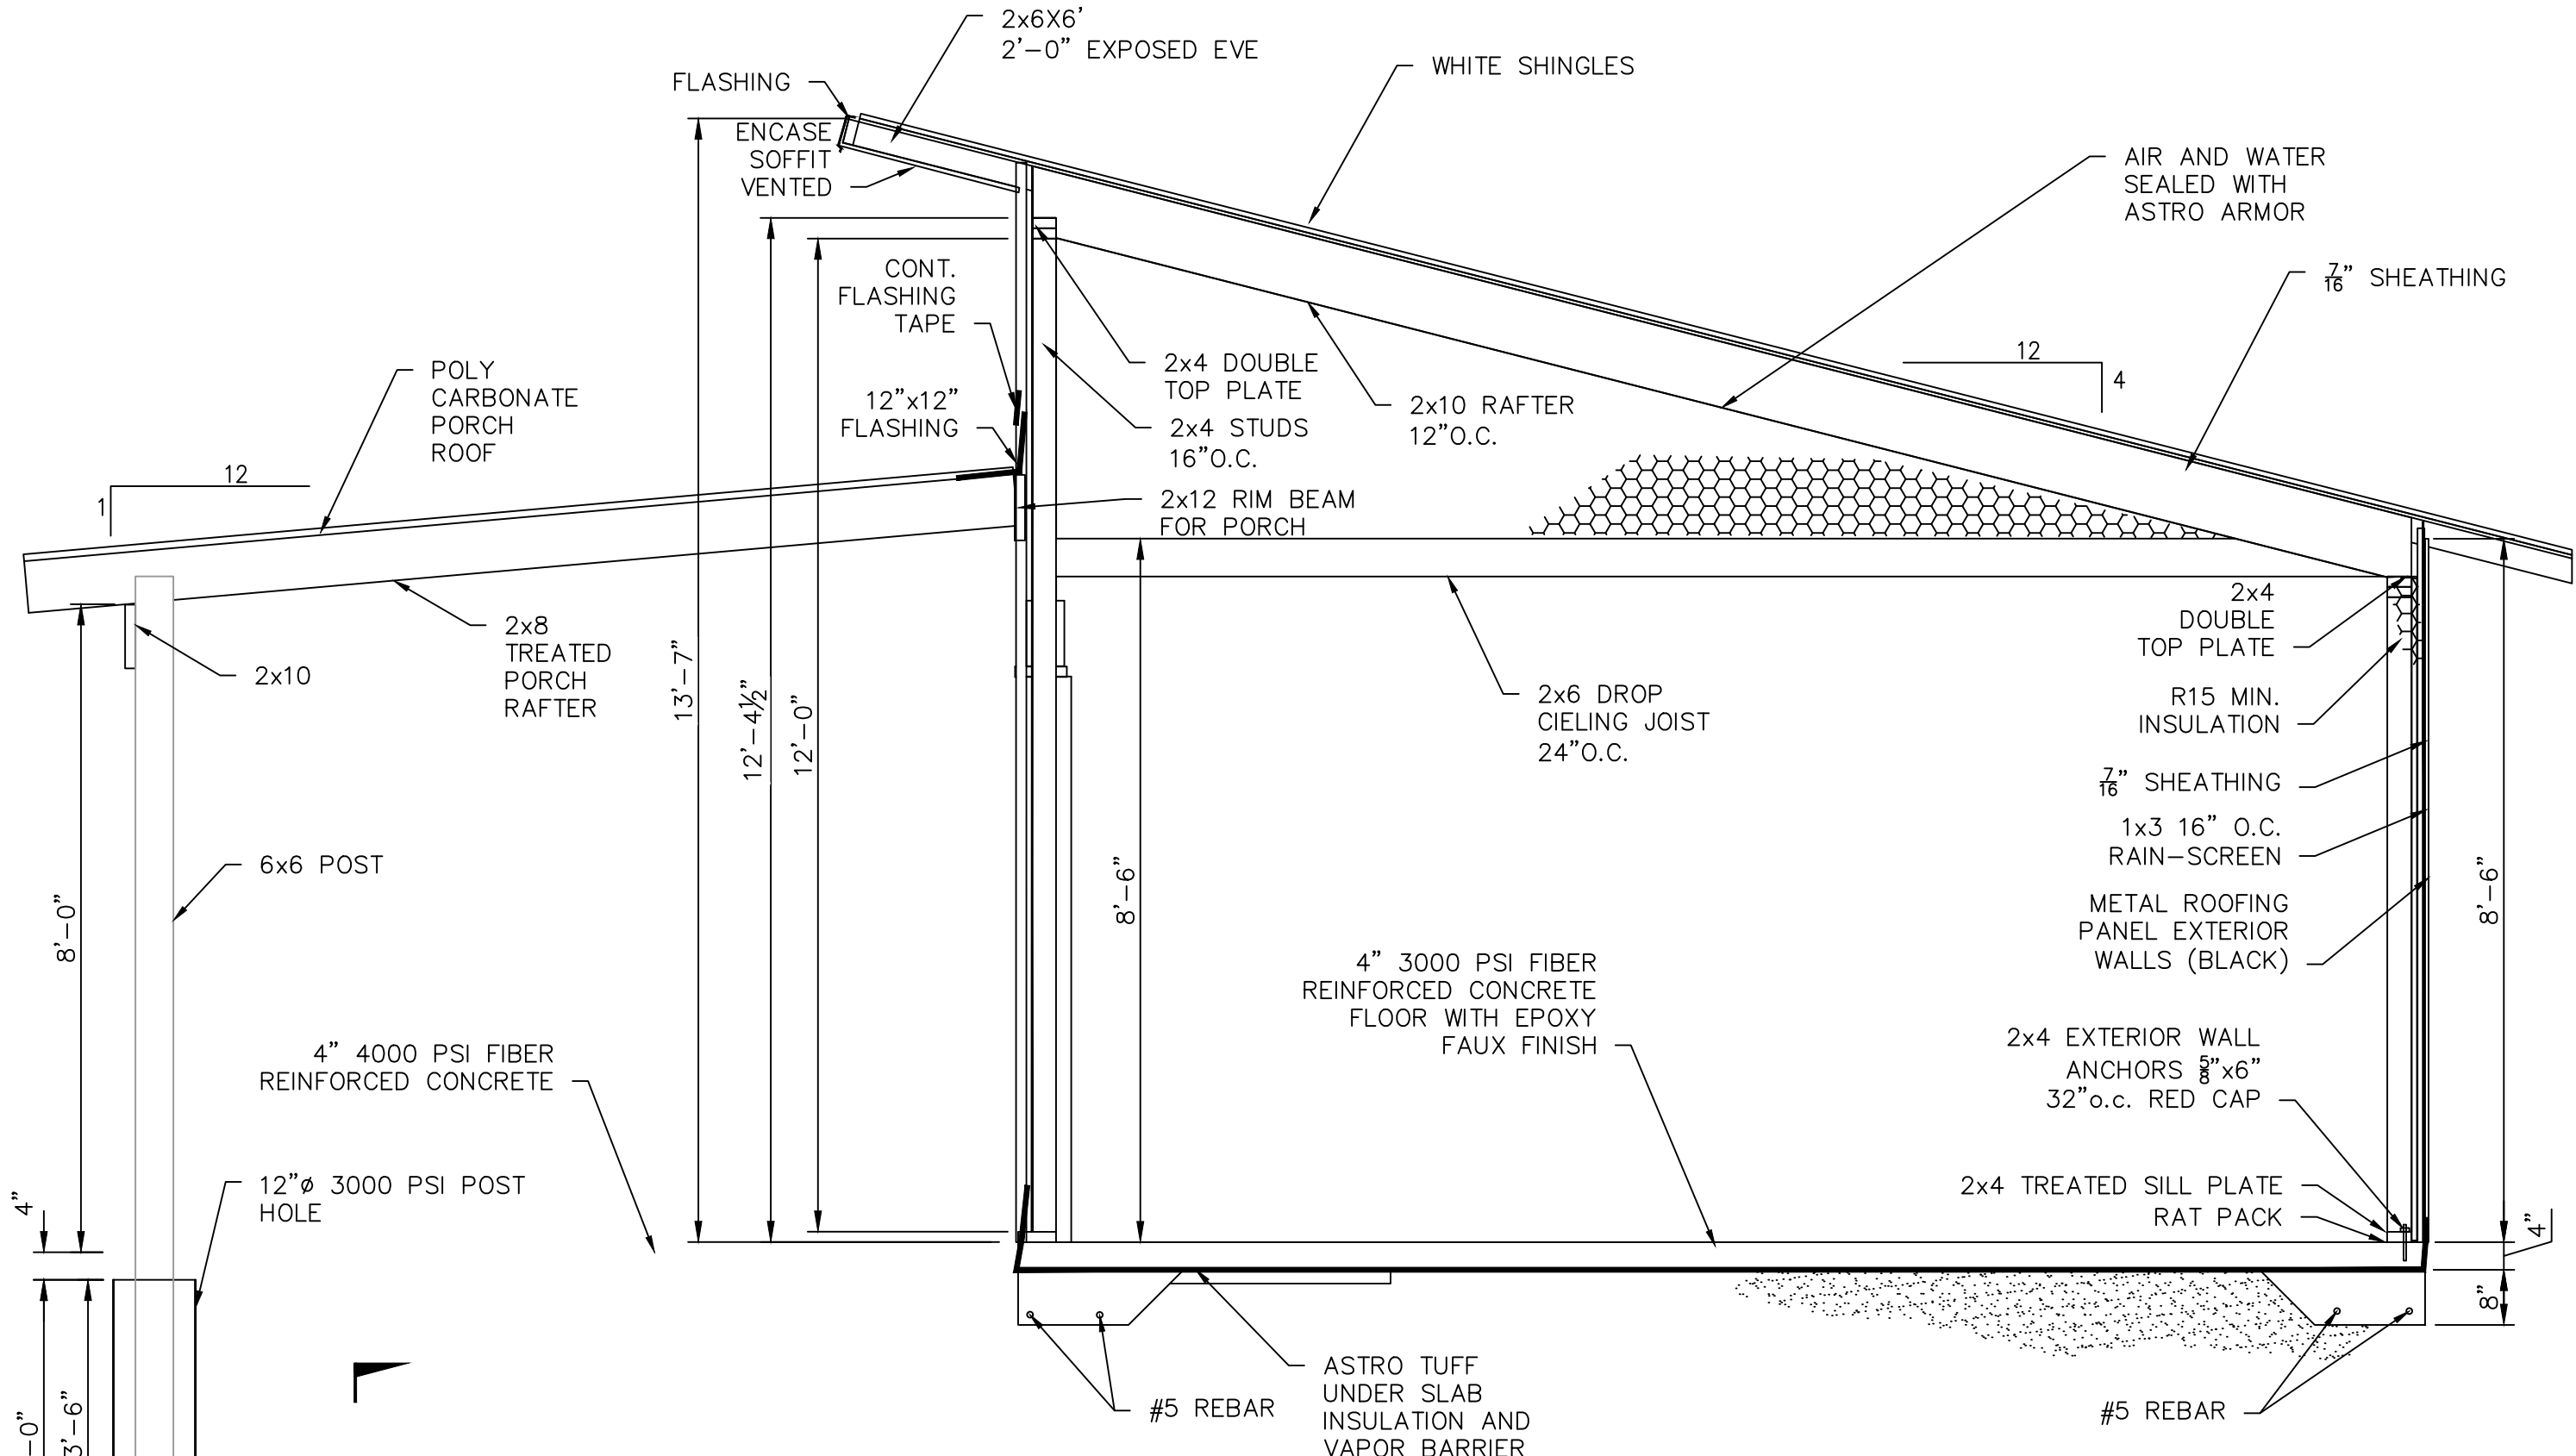

THIS DRAWING
A

SECTION A
SCALE: 1/4"=1'-0" THIS DRAWING

**BRZIGN
DESIGN**
1718 HIGHLAND
DR
DRAWING NO.
SECTION CUT A

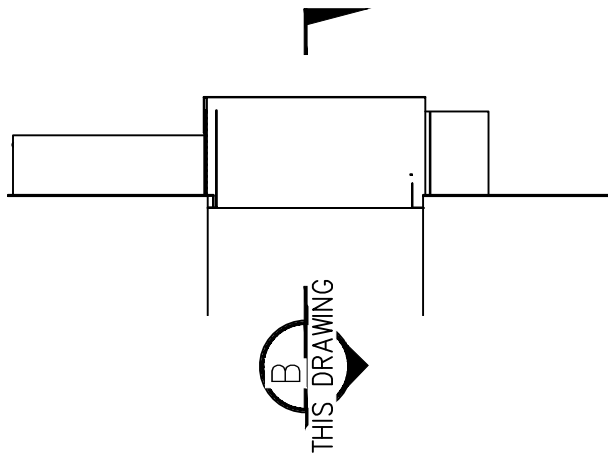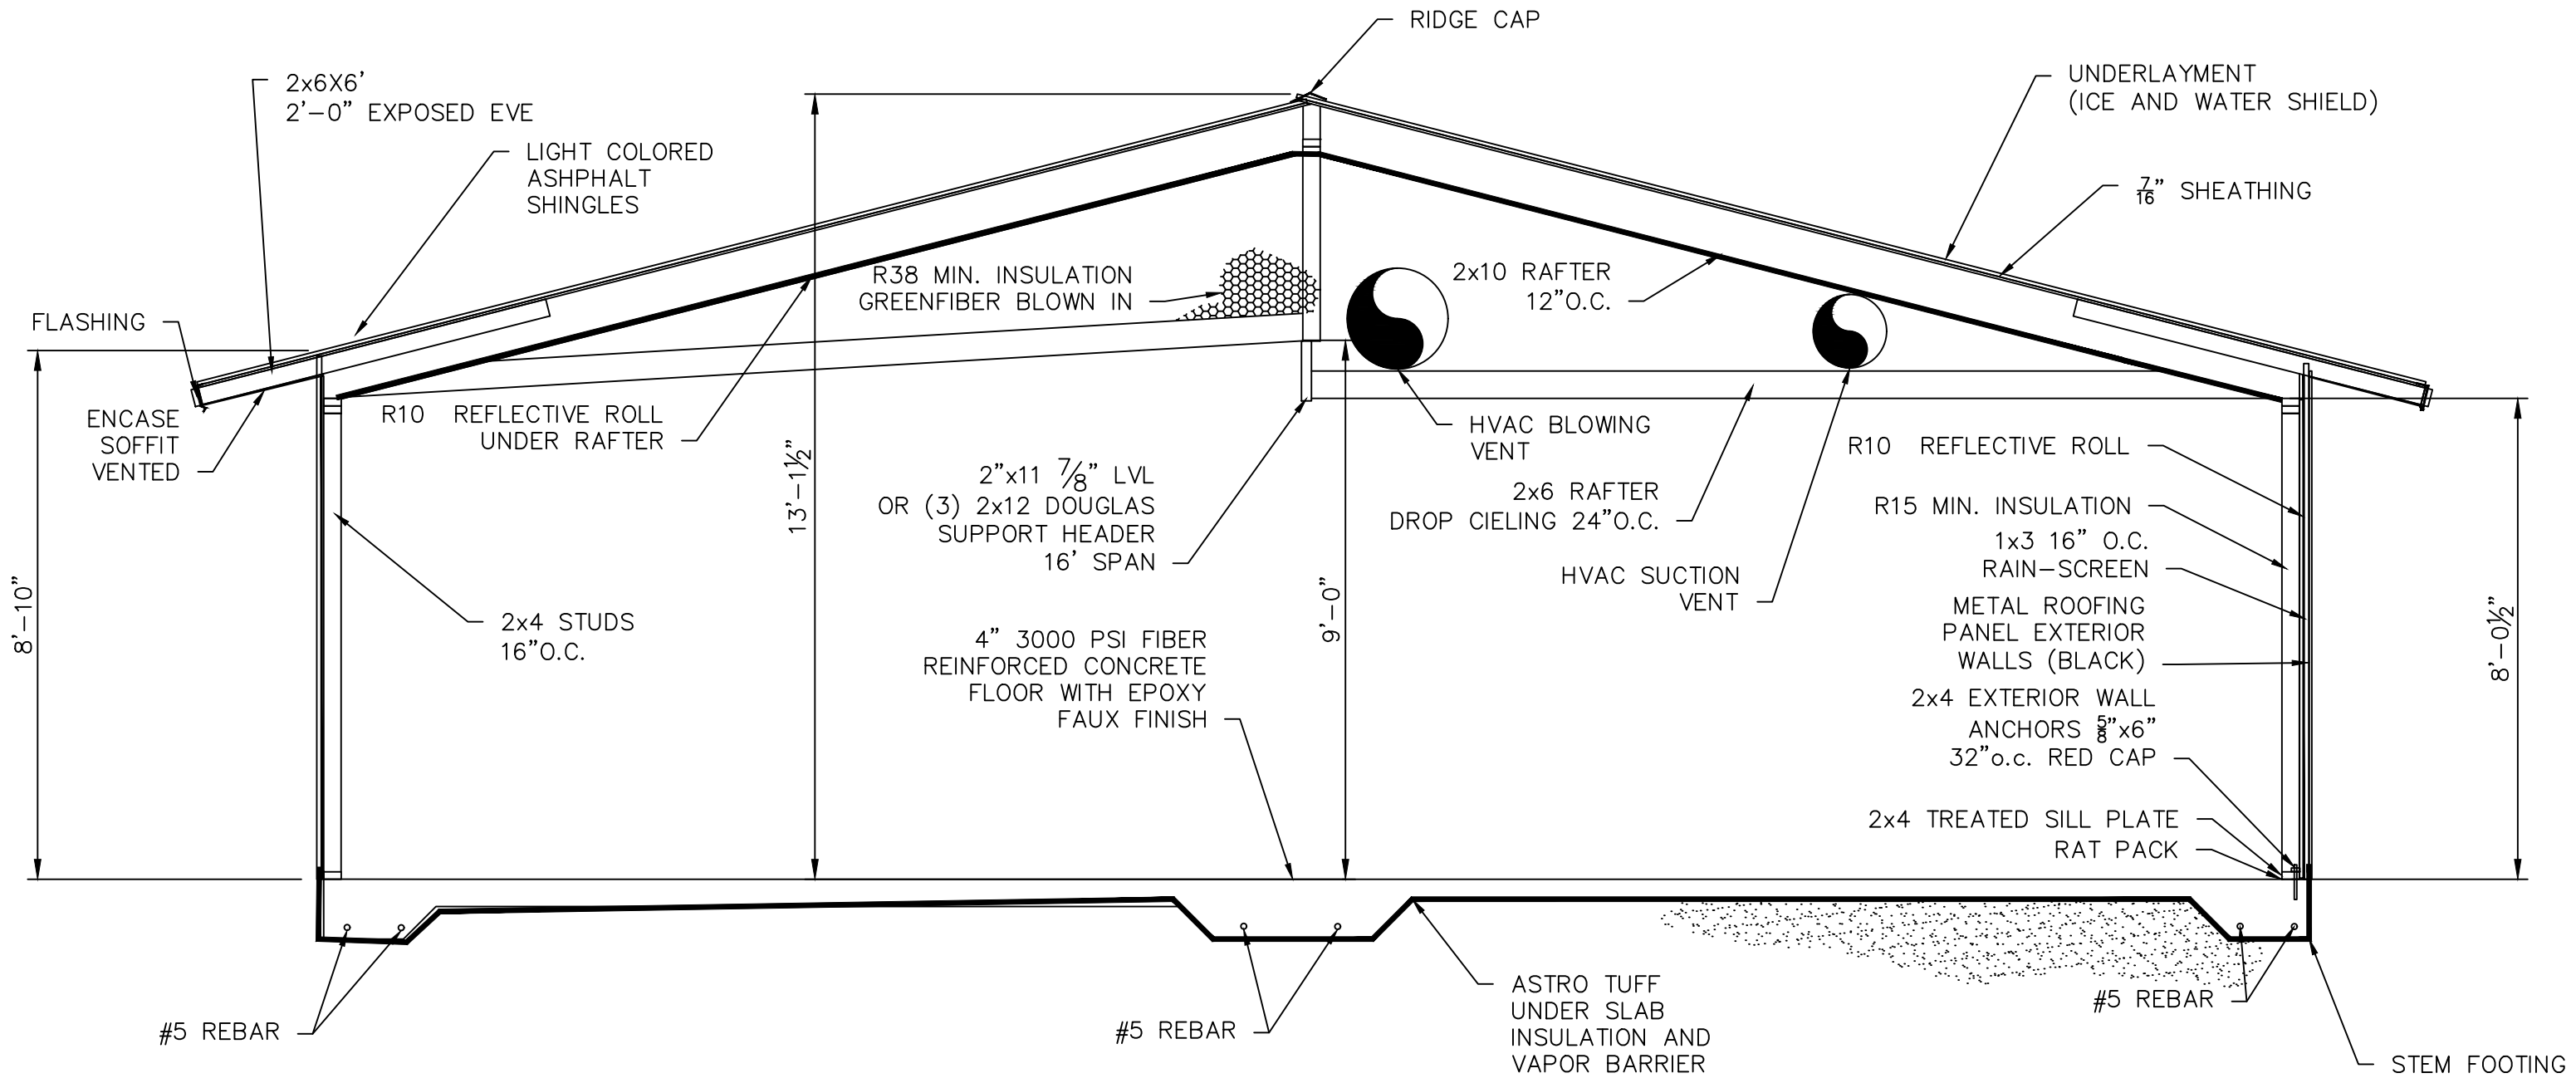


SECTION B
 SCALE: 3/8"=1'-0" THIS DRAWING

**BEZIGN
DESIGN**

1718 HIGHLAND
DR

DRAWING NO.
SECTION CUT B

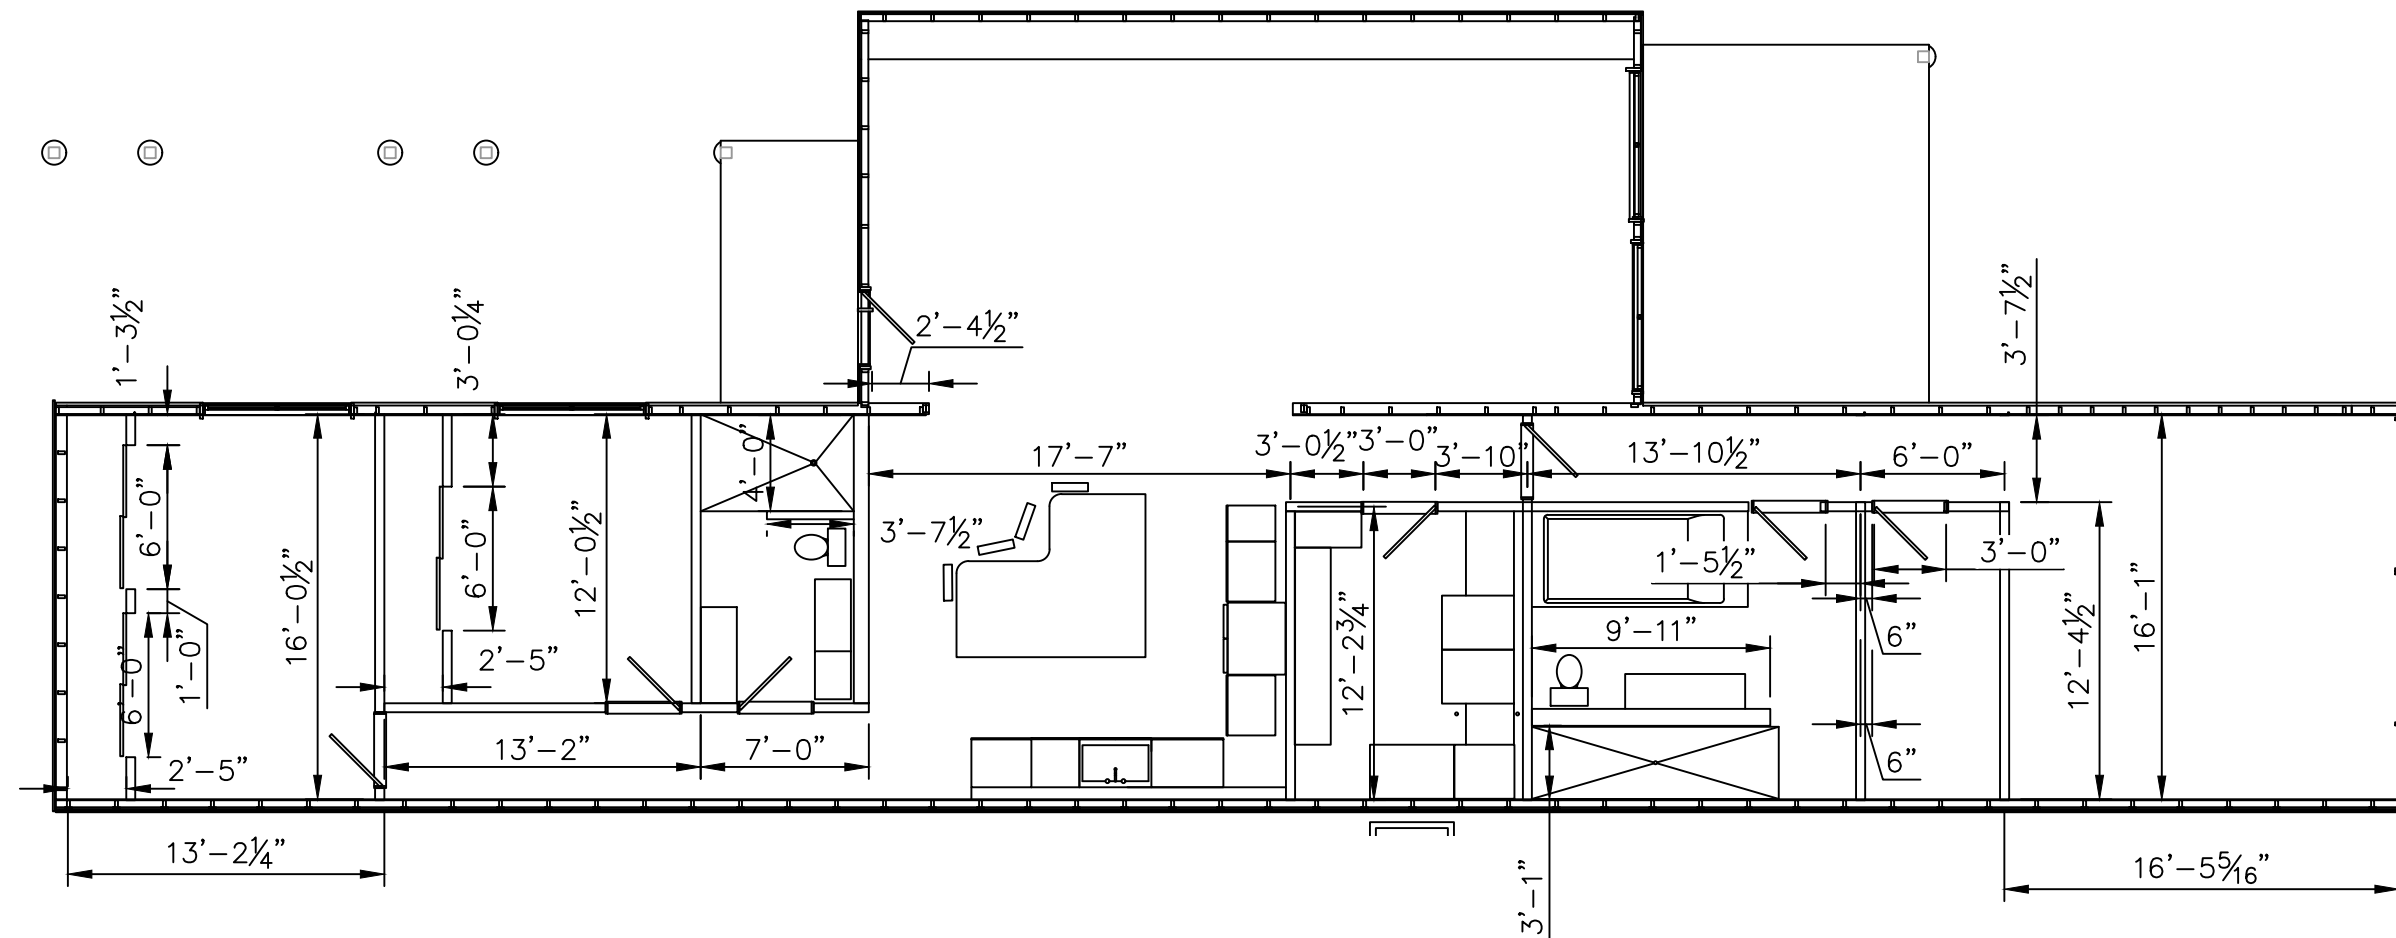


FLOOR PLAN
SCALE: 3/16" = 1'-0"

**REZIGN
DESIGN**


1718 HIGHLAND DR

DRAWING NO.
FRAMING PLAN

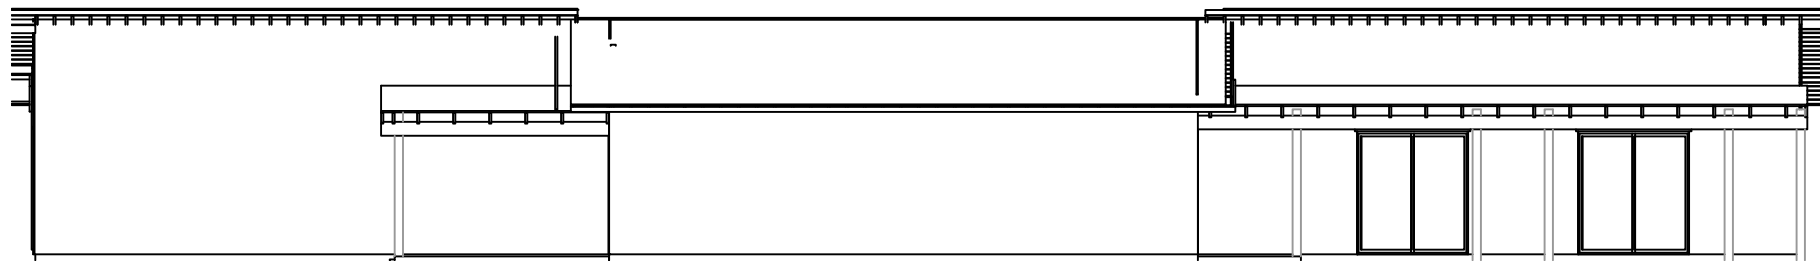


72x80 PD1 72x80 PD1

LEFT VIEW
SCALE: 3/32" = 1'-0"

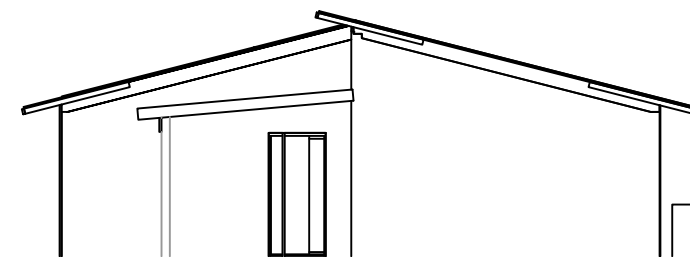

36x80 D1



FRONT VIEW
SCALE: 3/32" = 1'-0"

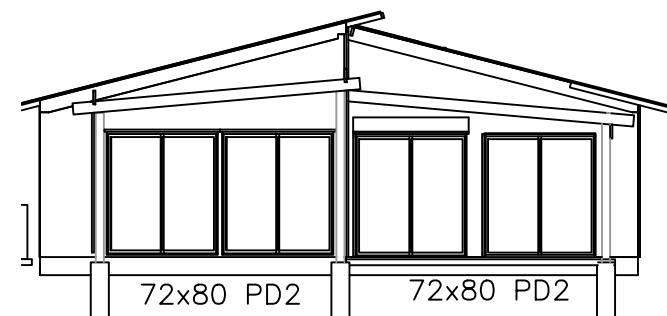

72x80 PD2

72x80 PD2

BACK VIEW
SCALE: 3/32" = 1'-0"

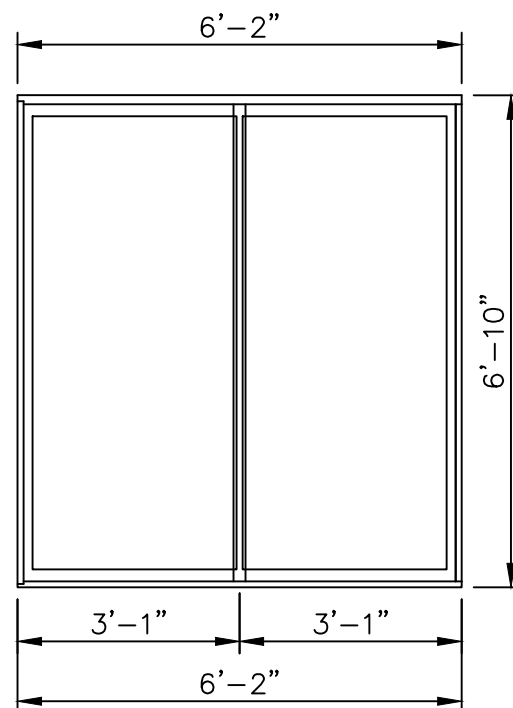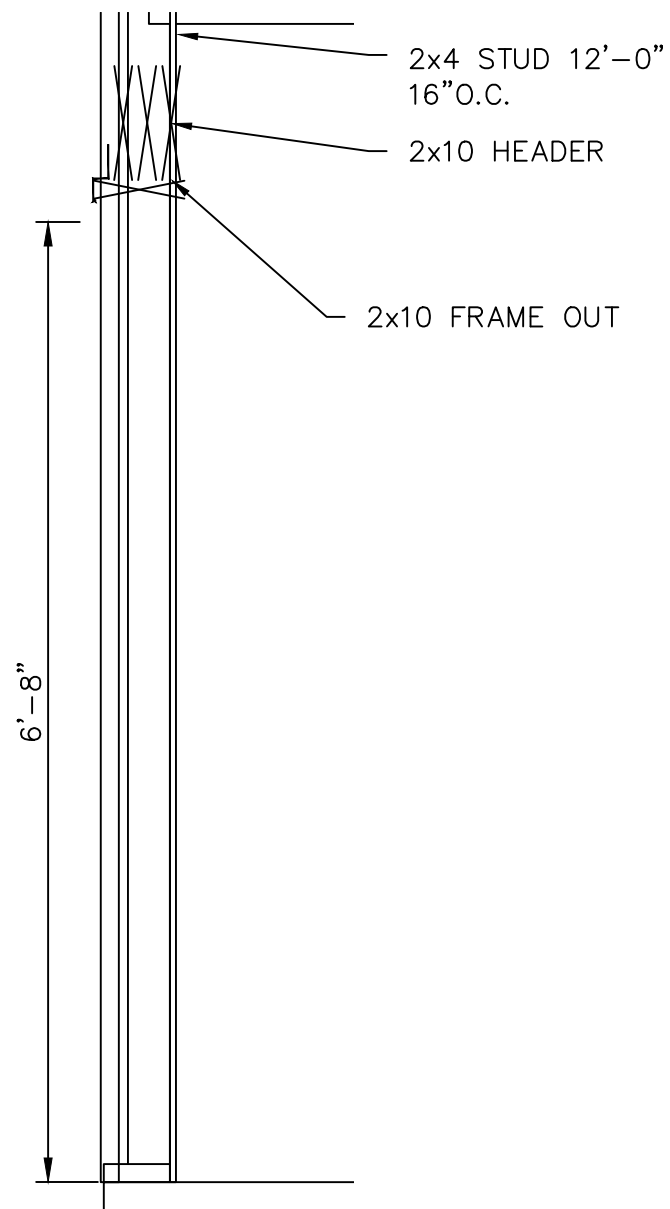


96x80 3 FIXED WINDOW (PD2) (6)

SCALE: 3/8" = 1'-0"
STANDARD SIZE OFF THE SHELF

**REZIGN
DESIGN**

1718 HIGHLAND
DR

DRAWING NO.
WINDOWS

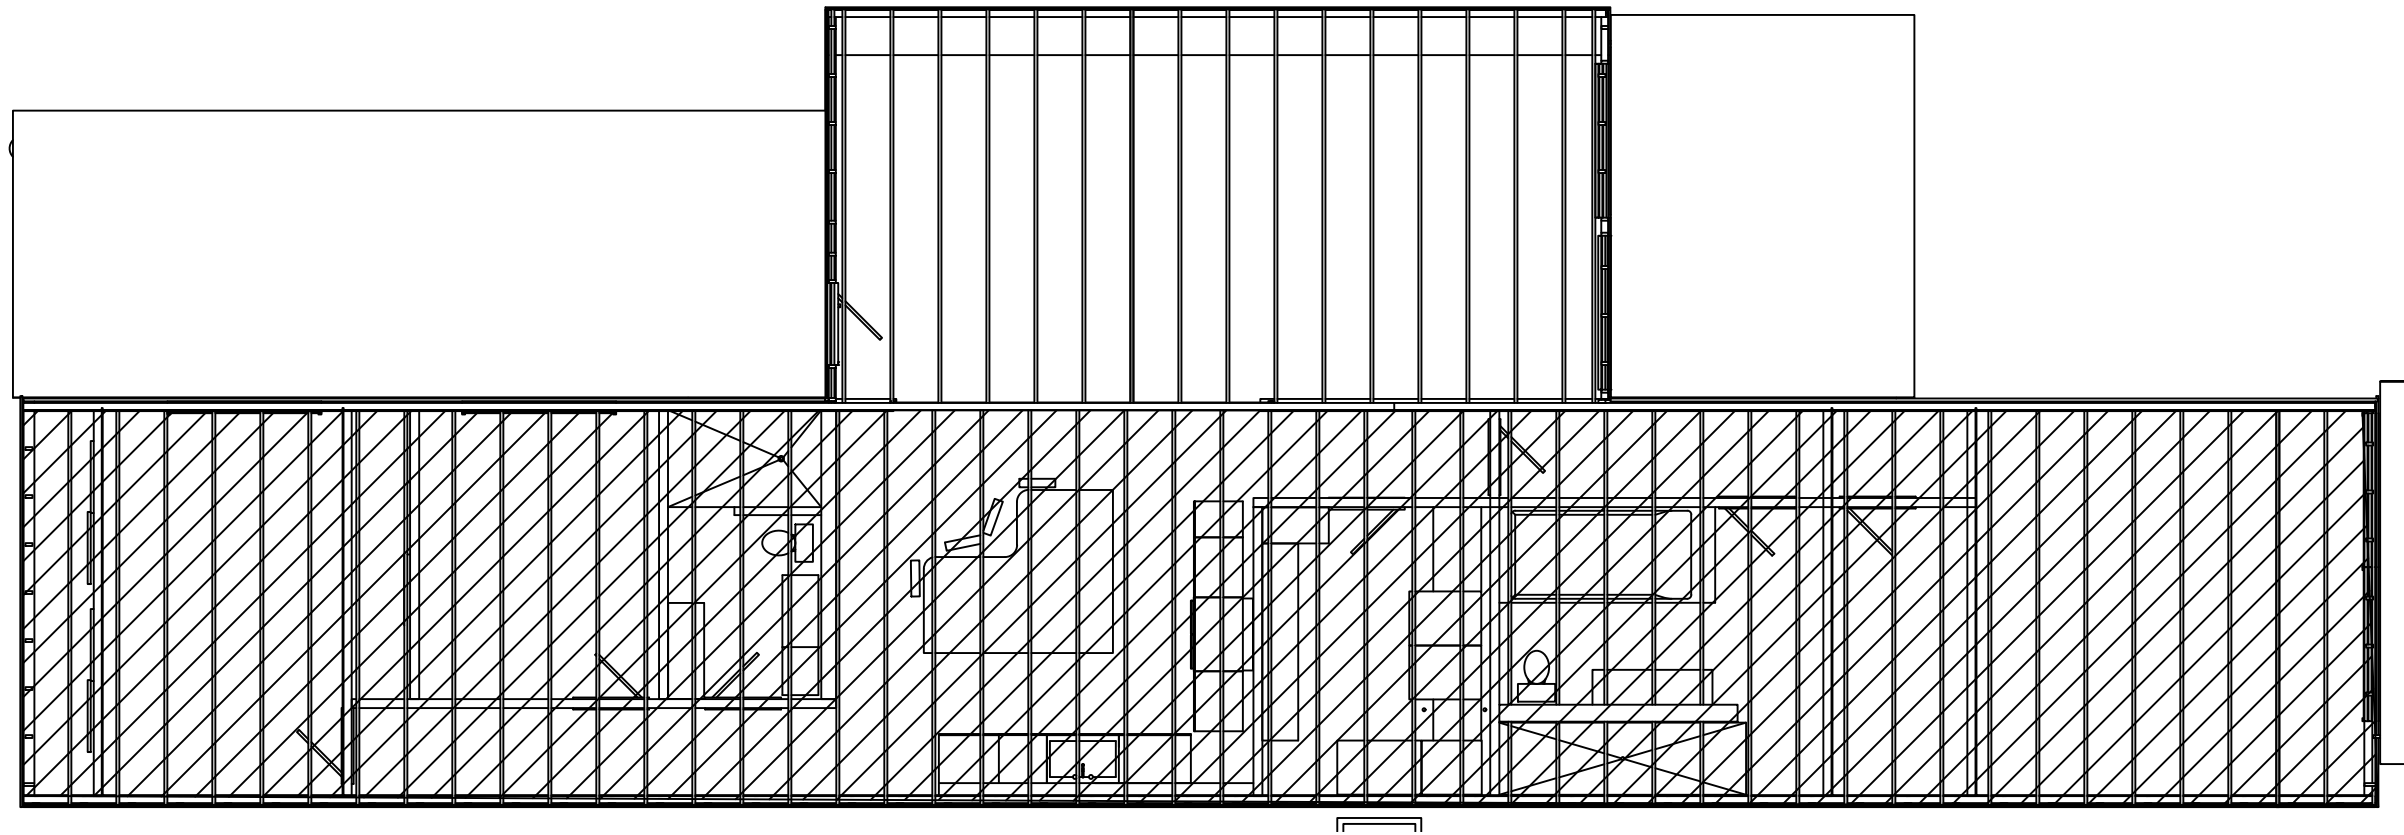

DROP CIELING LAYOUT


SCALE: 1/8" = 1'-0"

 DROP
CIELING

*REZIGN
DESIGN*

1718 HIGHLAND DR

DRAWING NO.
DROP CIELING

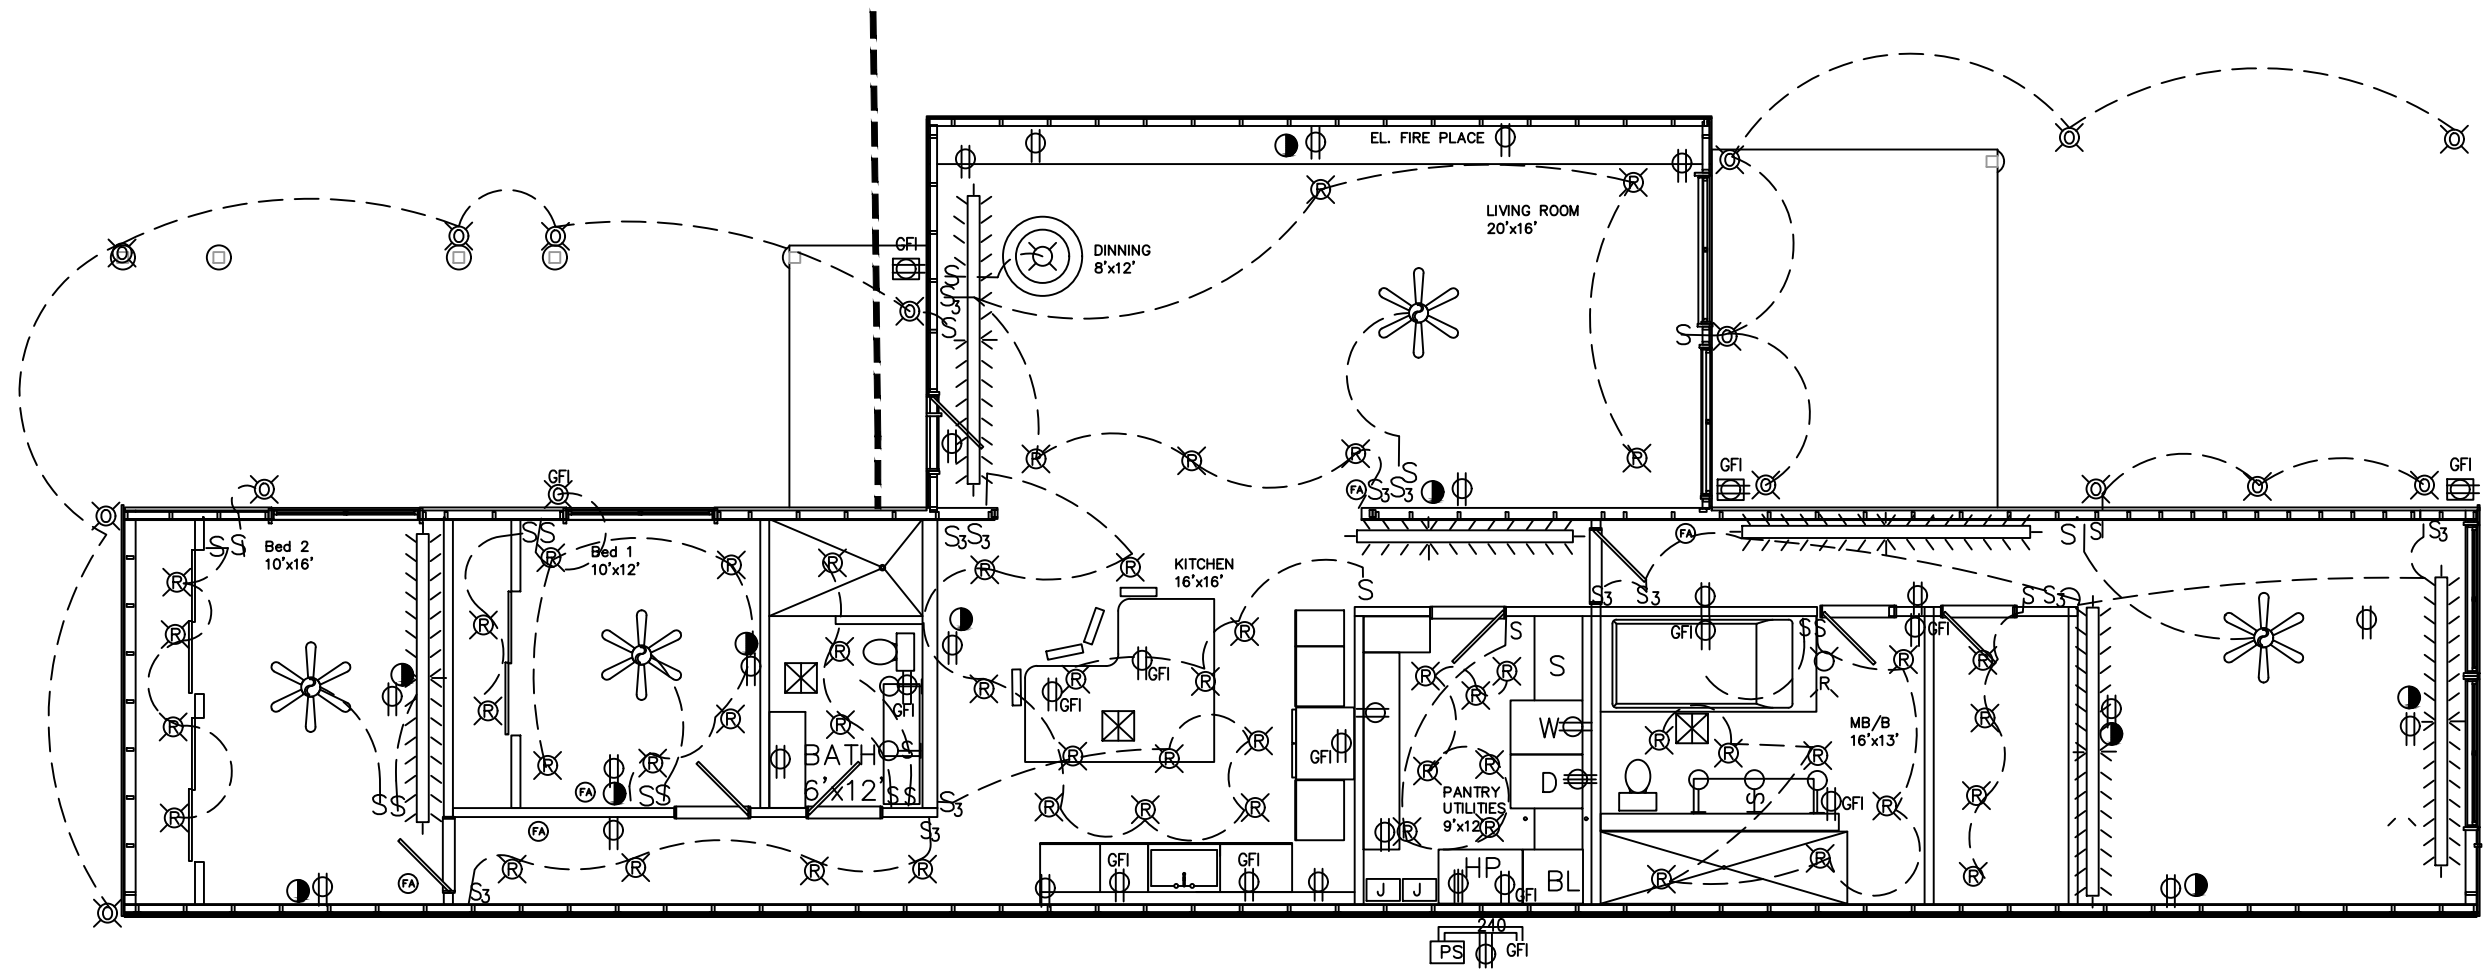

300AMP
ELECTRIC MAIN LINE

150 AMP
LINE TO
STUDIO

ELECTRIC LAYOUT

SCALE: 1/8" = 1'-0"


- | | | | | | | | | | |
|--|---------------------|--|-----------------------|-----------------|--------------------------|--|-----------------|--|------------|
| | FANCY LIGHT | | EXHAUST FAN AND LIGHT | S | SWITCH | | JUNCTION BOX | | PHOTO AUTO |
| | WALL SCONCE | | LED TUBE LIGHT 8' | S ³ | SWITCH 3 WAY | | PULL BOX SWITCH | | |
| | RECESSED PUCK LIGHT | | 110 OUTLET | S ^{3D} | SWITCH 3 WAY WITH DIMMER | | FIRE ALARM | | |
| | PENDANT LIGHT | | 240 OUTLET | | OUTDOOR LIGHT | | CATV | | |
| | | | GFI OUTLET | | COVERED OUTLET | | EXHAUST FAN | | |




 
 


**REZIGN
DESIGN**


 
1718 HIGHLAND DR

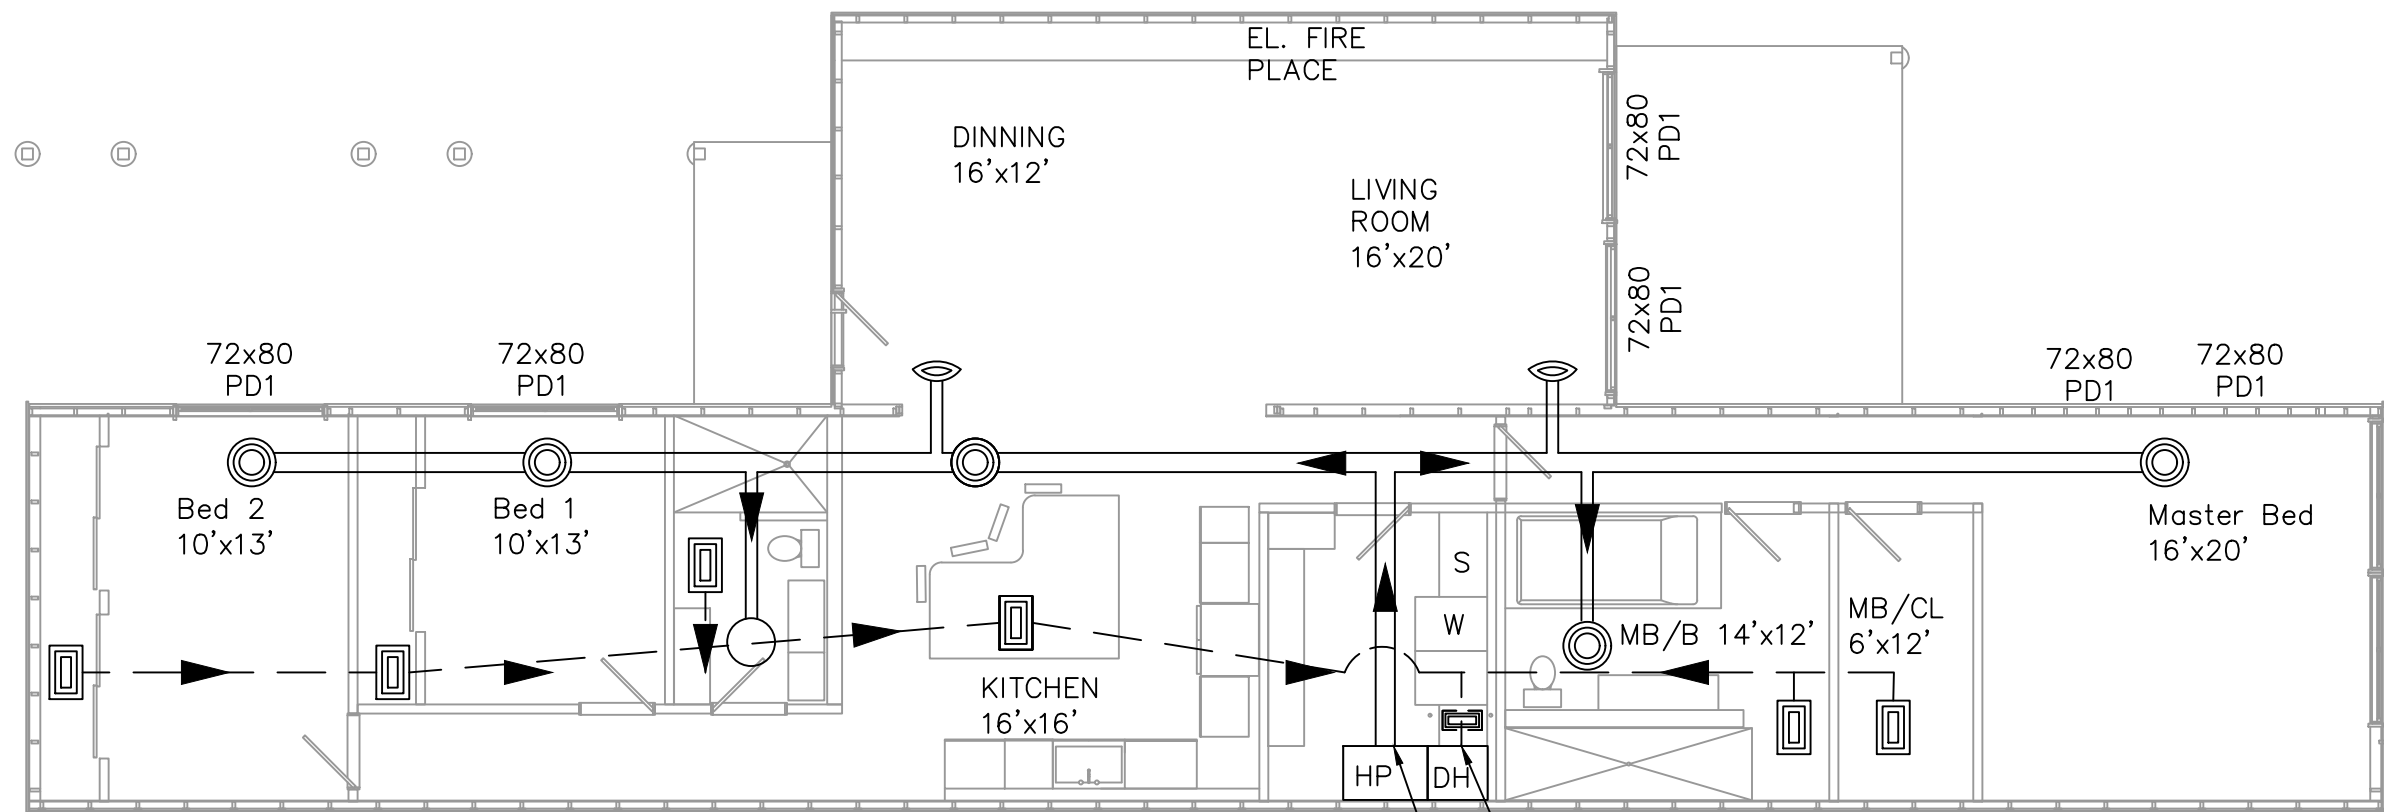DRAWING NO.
ELECTRICAL



-  WALL OUTPUT VENT
-  CEILING OUTPUT VENT
-  CEILING SUCTION VENT
-  SUCTION DUCT
-  OUTPUT DUCT

HVAC LAYOUT
 SCALE: 1/8" = 1'-0"


-  INTAKE BLOWER
-  AC COMPRESSOR



**BRZIGN
DESIGN**


1718 HIGHLAND DR

DRAWING NO.
HVAC

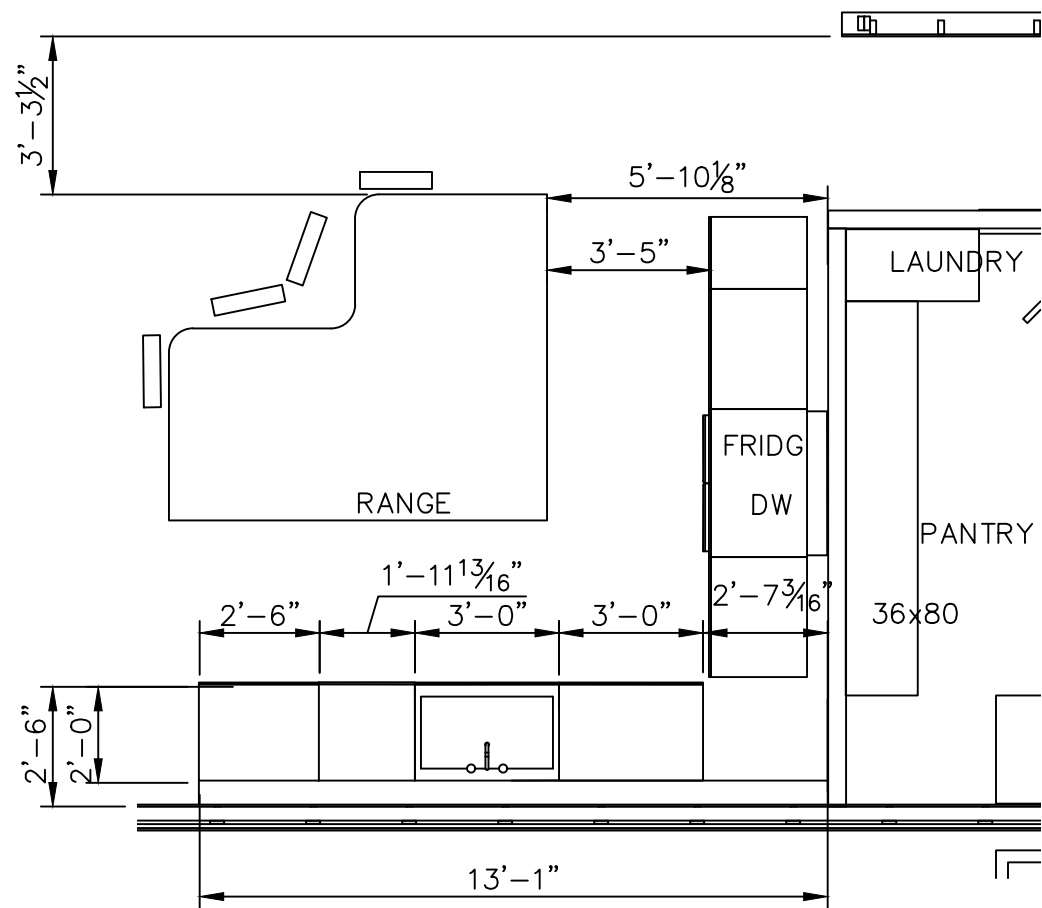


KITCHEN FLOOR PLAN

SCALE: 1/4" = 1'-0"

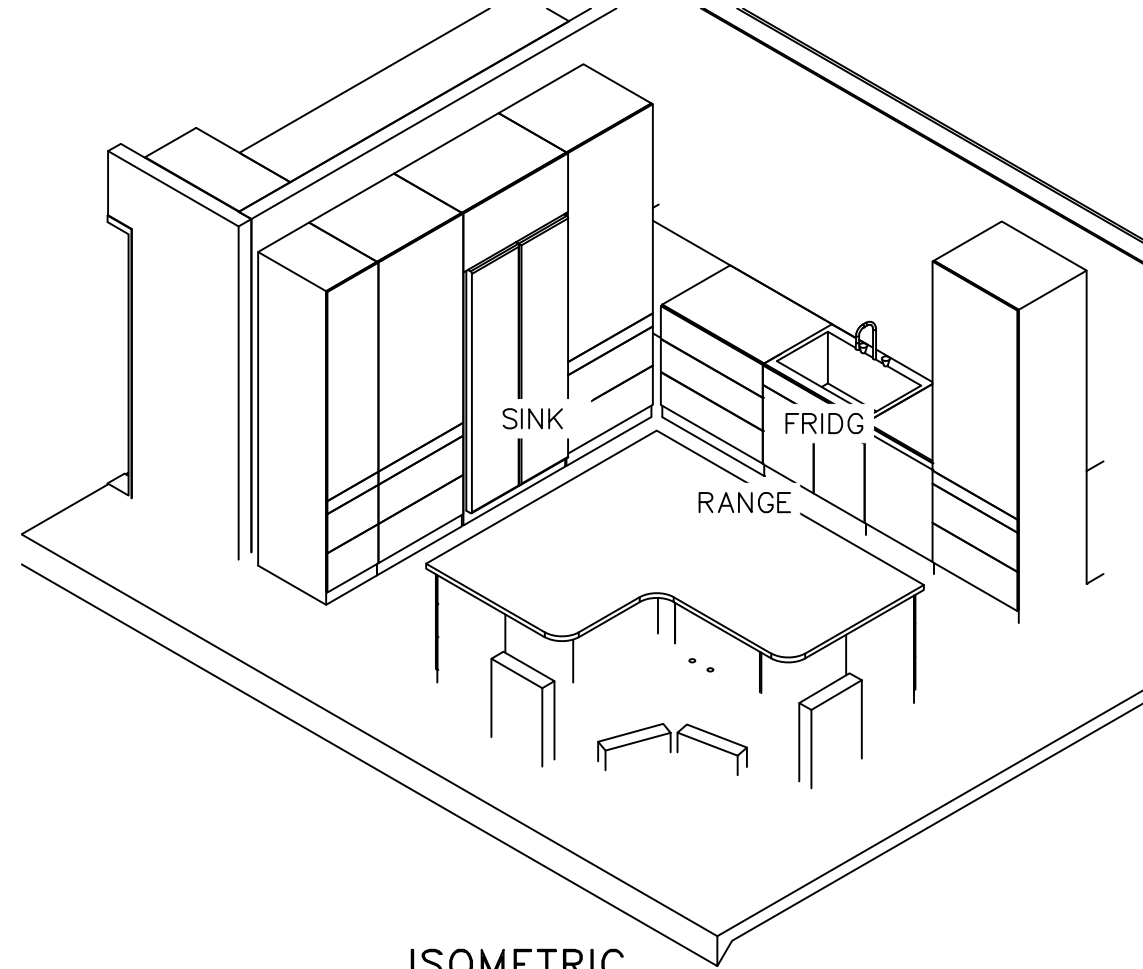


ISOMETRIC

SCALE: 1/4" = 1'-0"

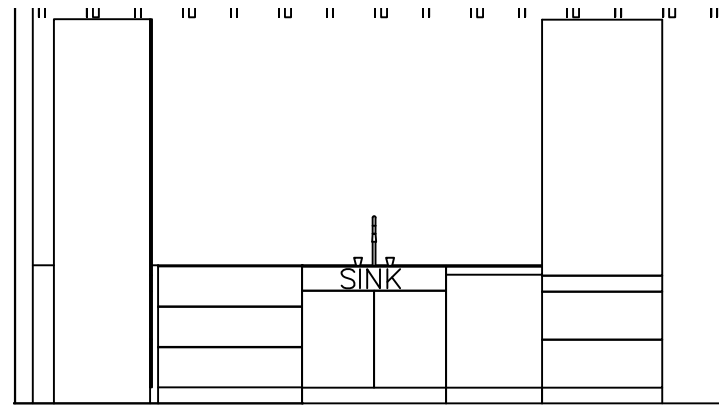

**KITCHEN CABINET WALL 1
ELEVATION**

SCALE: 1/4" = 1'-0"

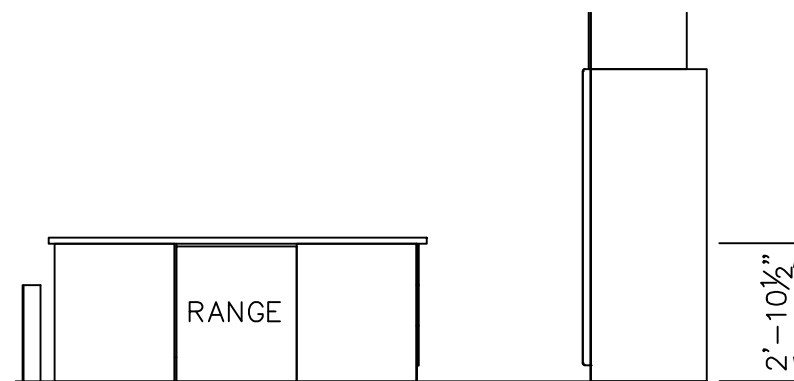


**KITCHEN ISLAND
ELEVATION**

SCALE: 1/4" = 1'-0"


**BEZIGN
DESIGN**


1718 HIGHLAND DR

DRAWING NO.
KITCHEN

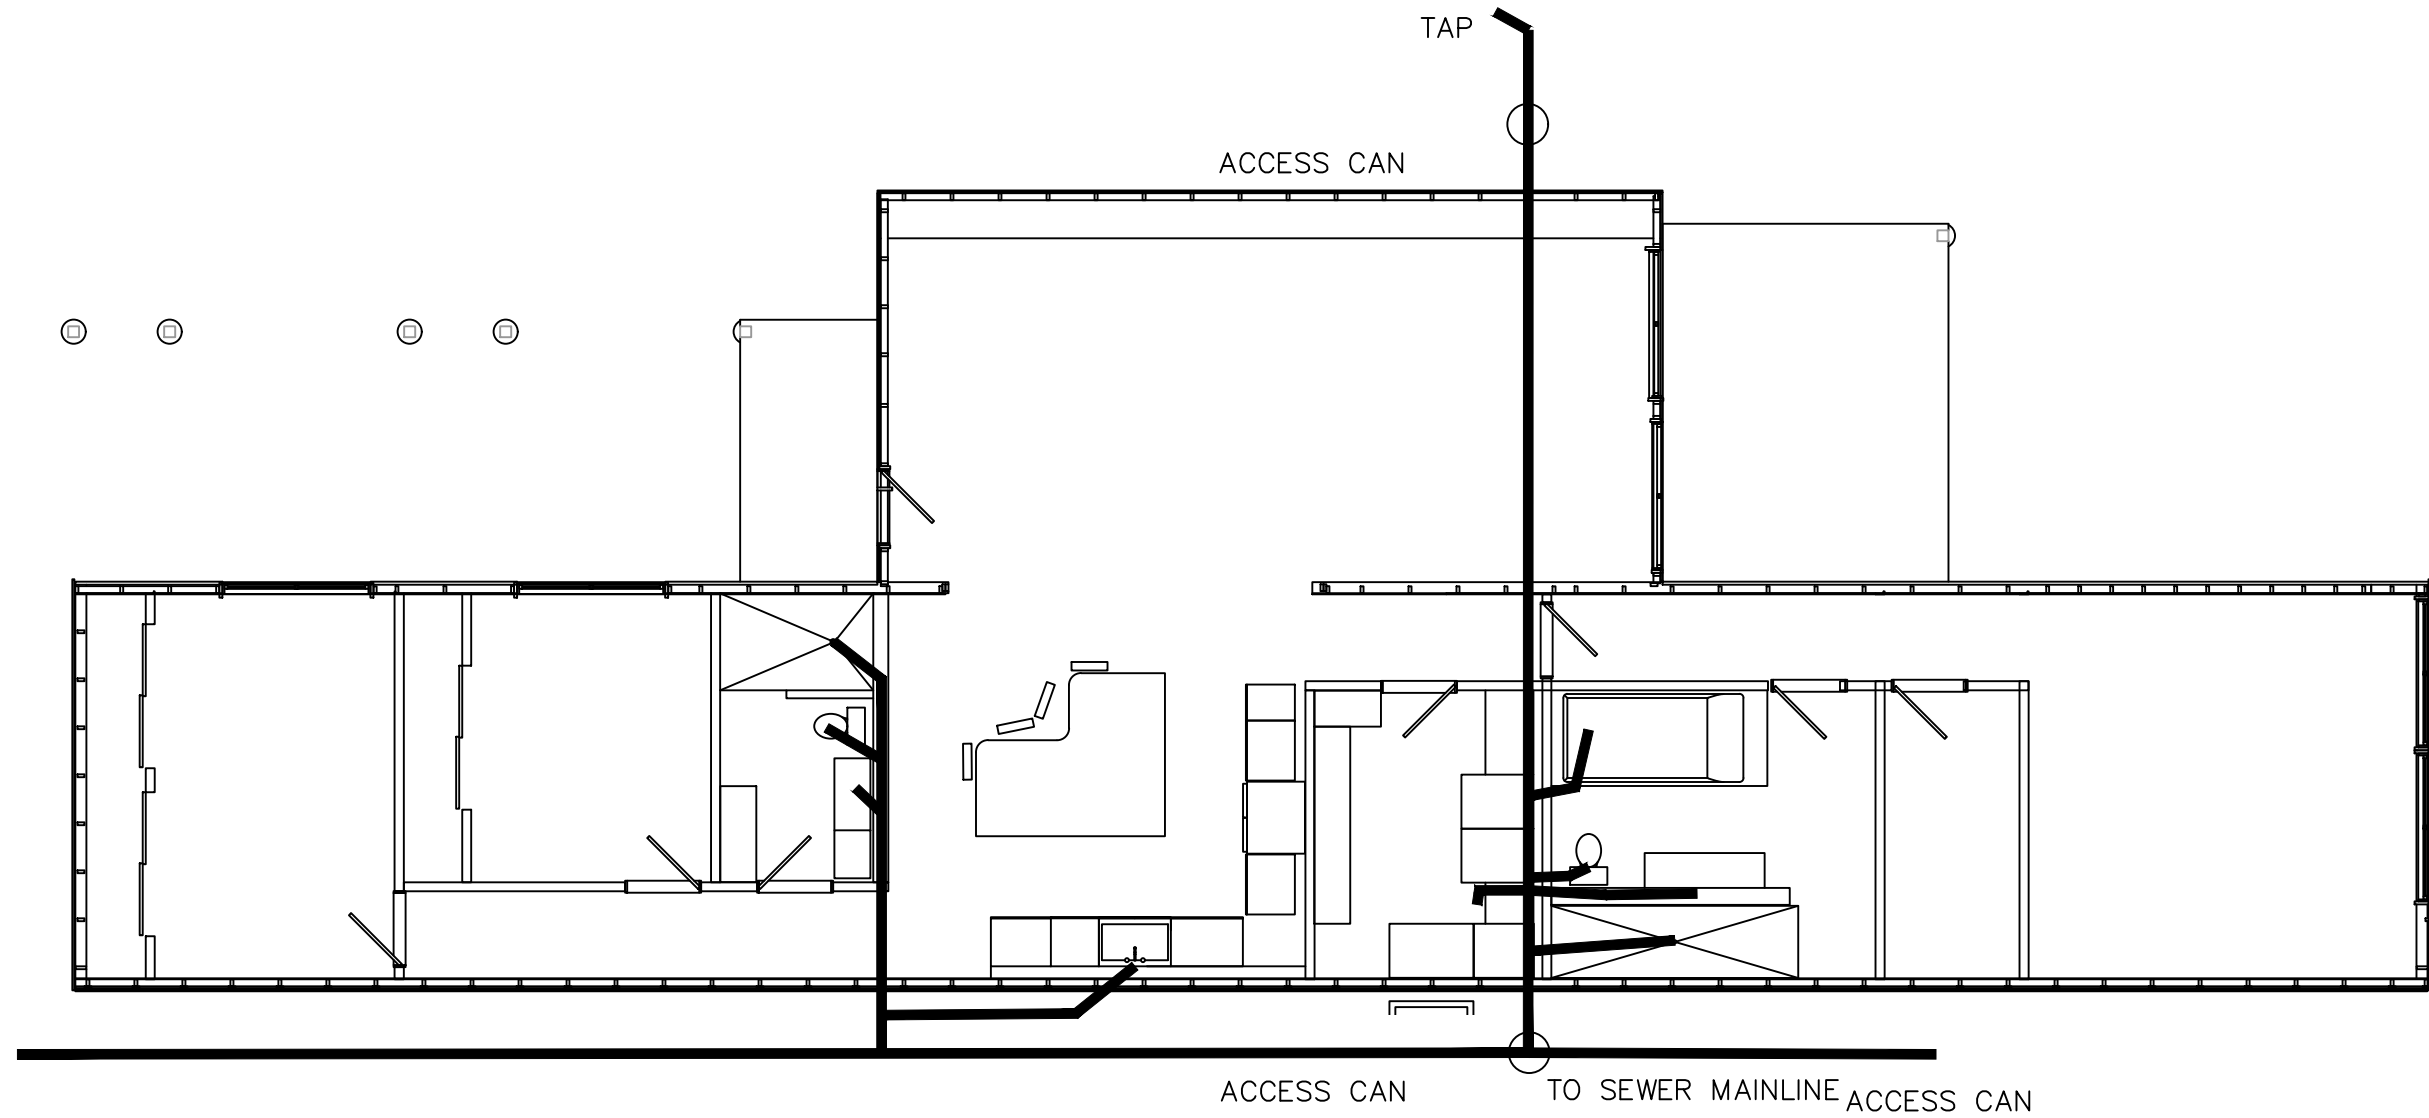

SANITATION LINE LAYOUT
 SCALE: 3/16" = 1'-0"


**BRZIGN
 DESIGN**
 1718 HIGHLAND DR
 DRAWING NO.
 SAN DRAIN

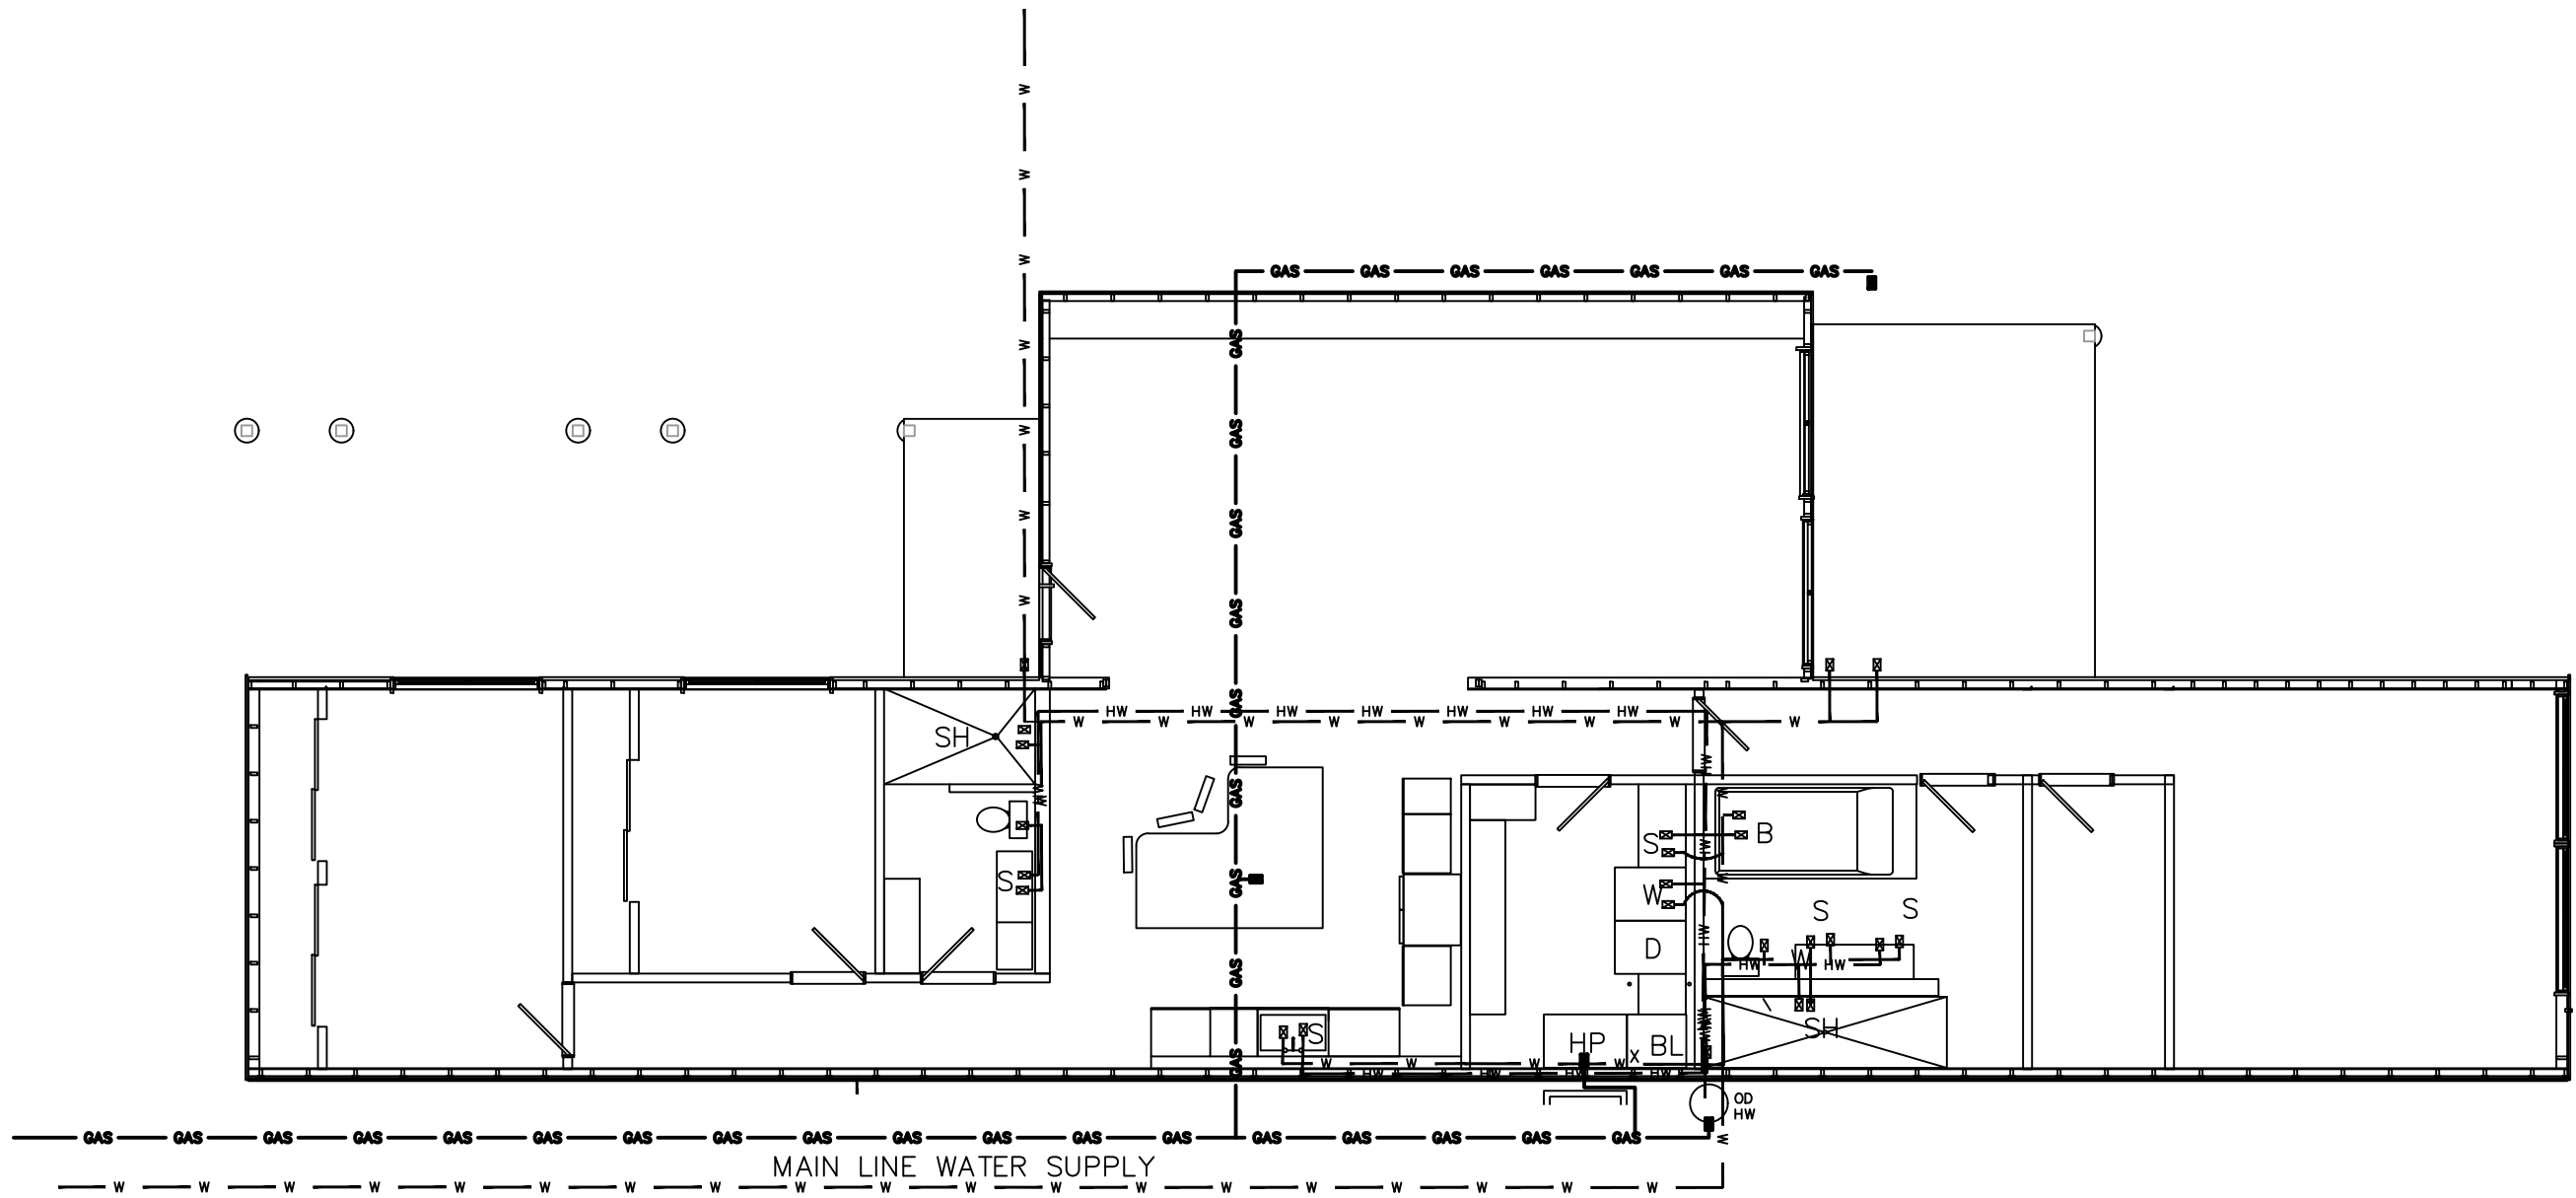

OD/HW = ON DEMAND HOT WATER HEATER 110V
 GAS LINE ——— GAS ———


PLUMBING LAYOUT
 SCALE: 1/8" = 1'-0"

REZIGN DESIGN

1718 HIGHLAND DR

DRAWING NO.
 WATER SUPPLY

HIGHLAND DR.

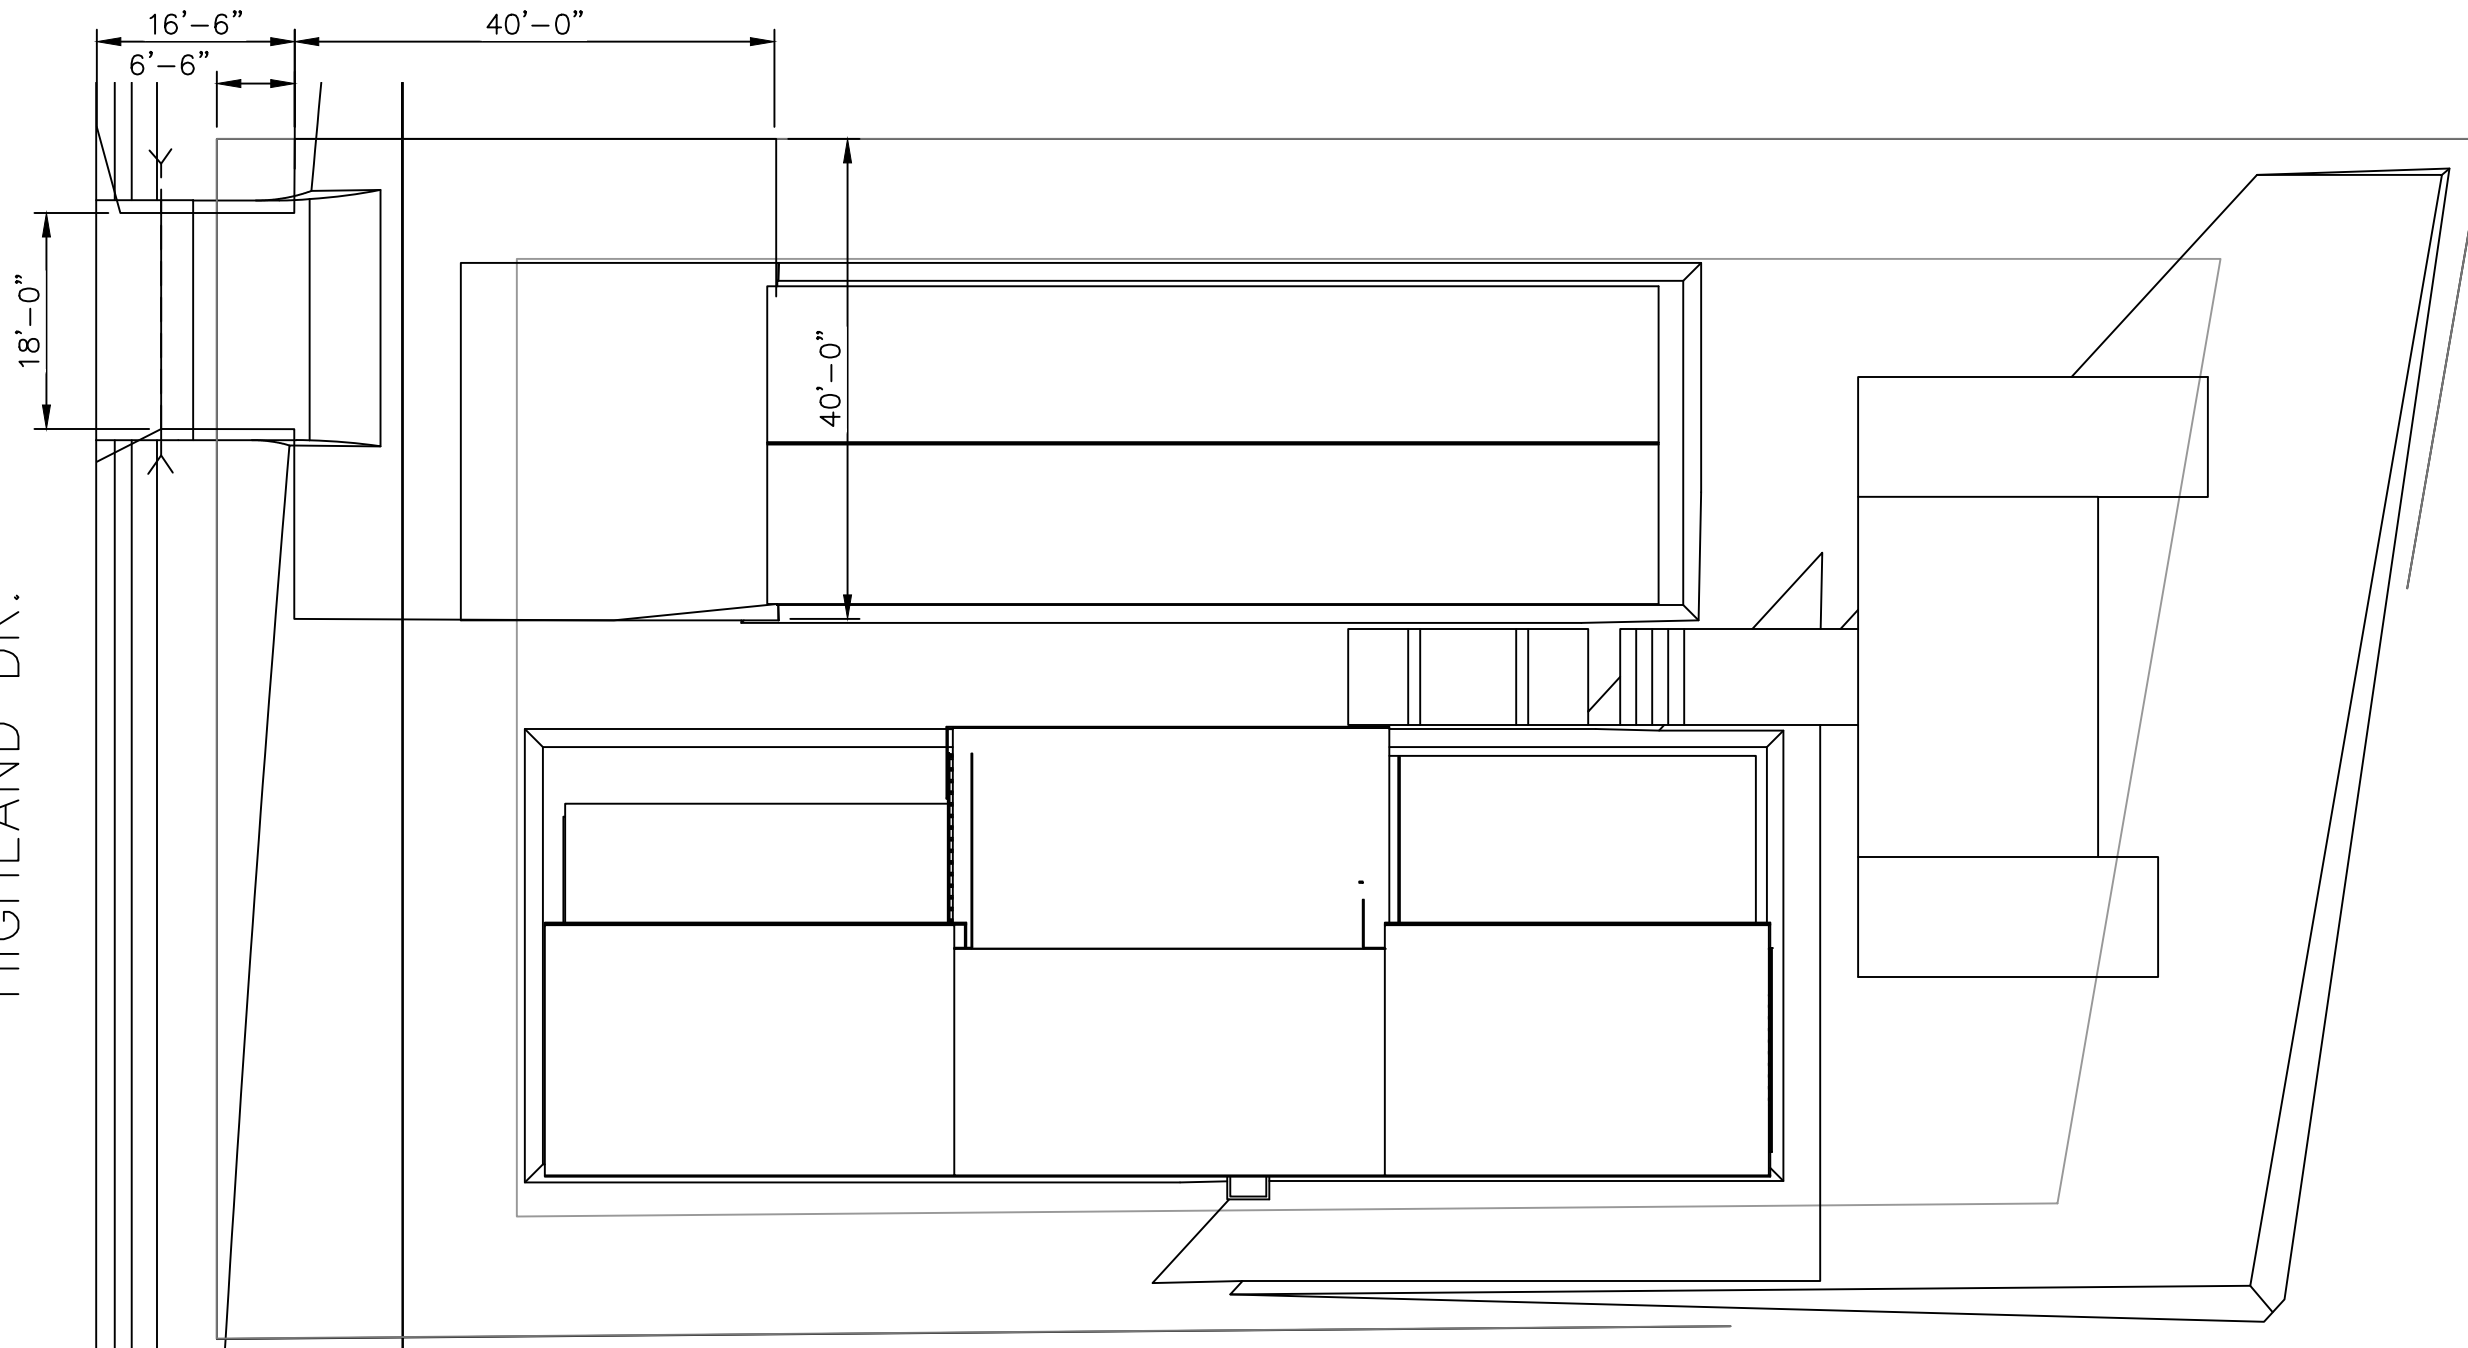

**BRZIGN
DESIGN**

1718 HIGHLAND DR

DRAWING NO.
DRIVE