



PARAGON
HOME DESIGNS

809-A OAKHURST DR.
EVANS, G.A. 30809
OFFICE: 706-364-8554
FAX: 706-955-7945


Revision Table
Date Description

Date	Description


DAKOTA-GR
PROJECT DESCRIPTION:
FOREVER HOMES

DISCLAIMER NOTES:
TO the best of my knowledge these plans are drawn to comply with owner's and/ or builder's specifications and any changes made after prints are made and/ or approved will be done at the owner's and/or builder's expense and responsibility. The contractor shall verify enclosed drawing for builder and/or owner's standards. PARAGON HOME DESIGNS LLC. is not liable for design discrepancies once construction has begun. While every effort has been made in the preparation of this plan to avoid any oversights, the maker can not guarantee against human error. The contractor of the job must check all dimensions and other details prior to construction and be solely responsible thereafter.


A-1
SHEET # 1 OF 4
SCALE: AS NOTED
DATE PRINTED: 2/29/2024

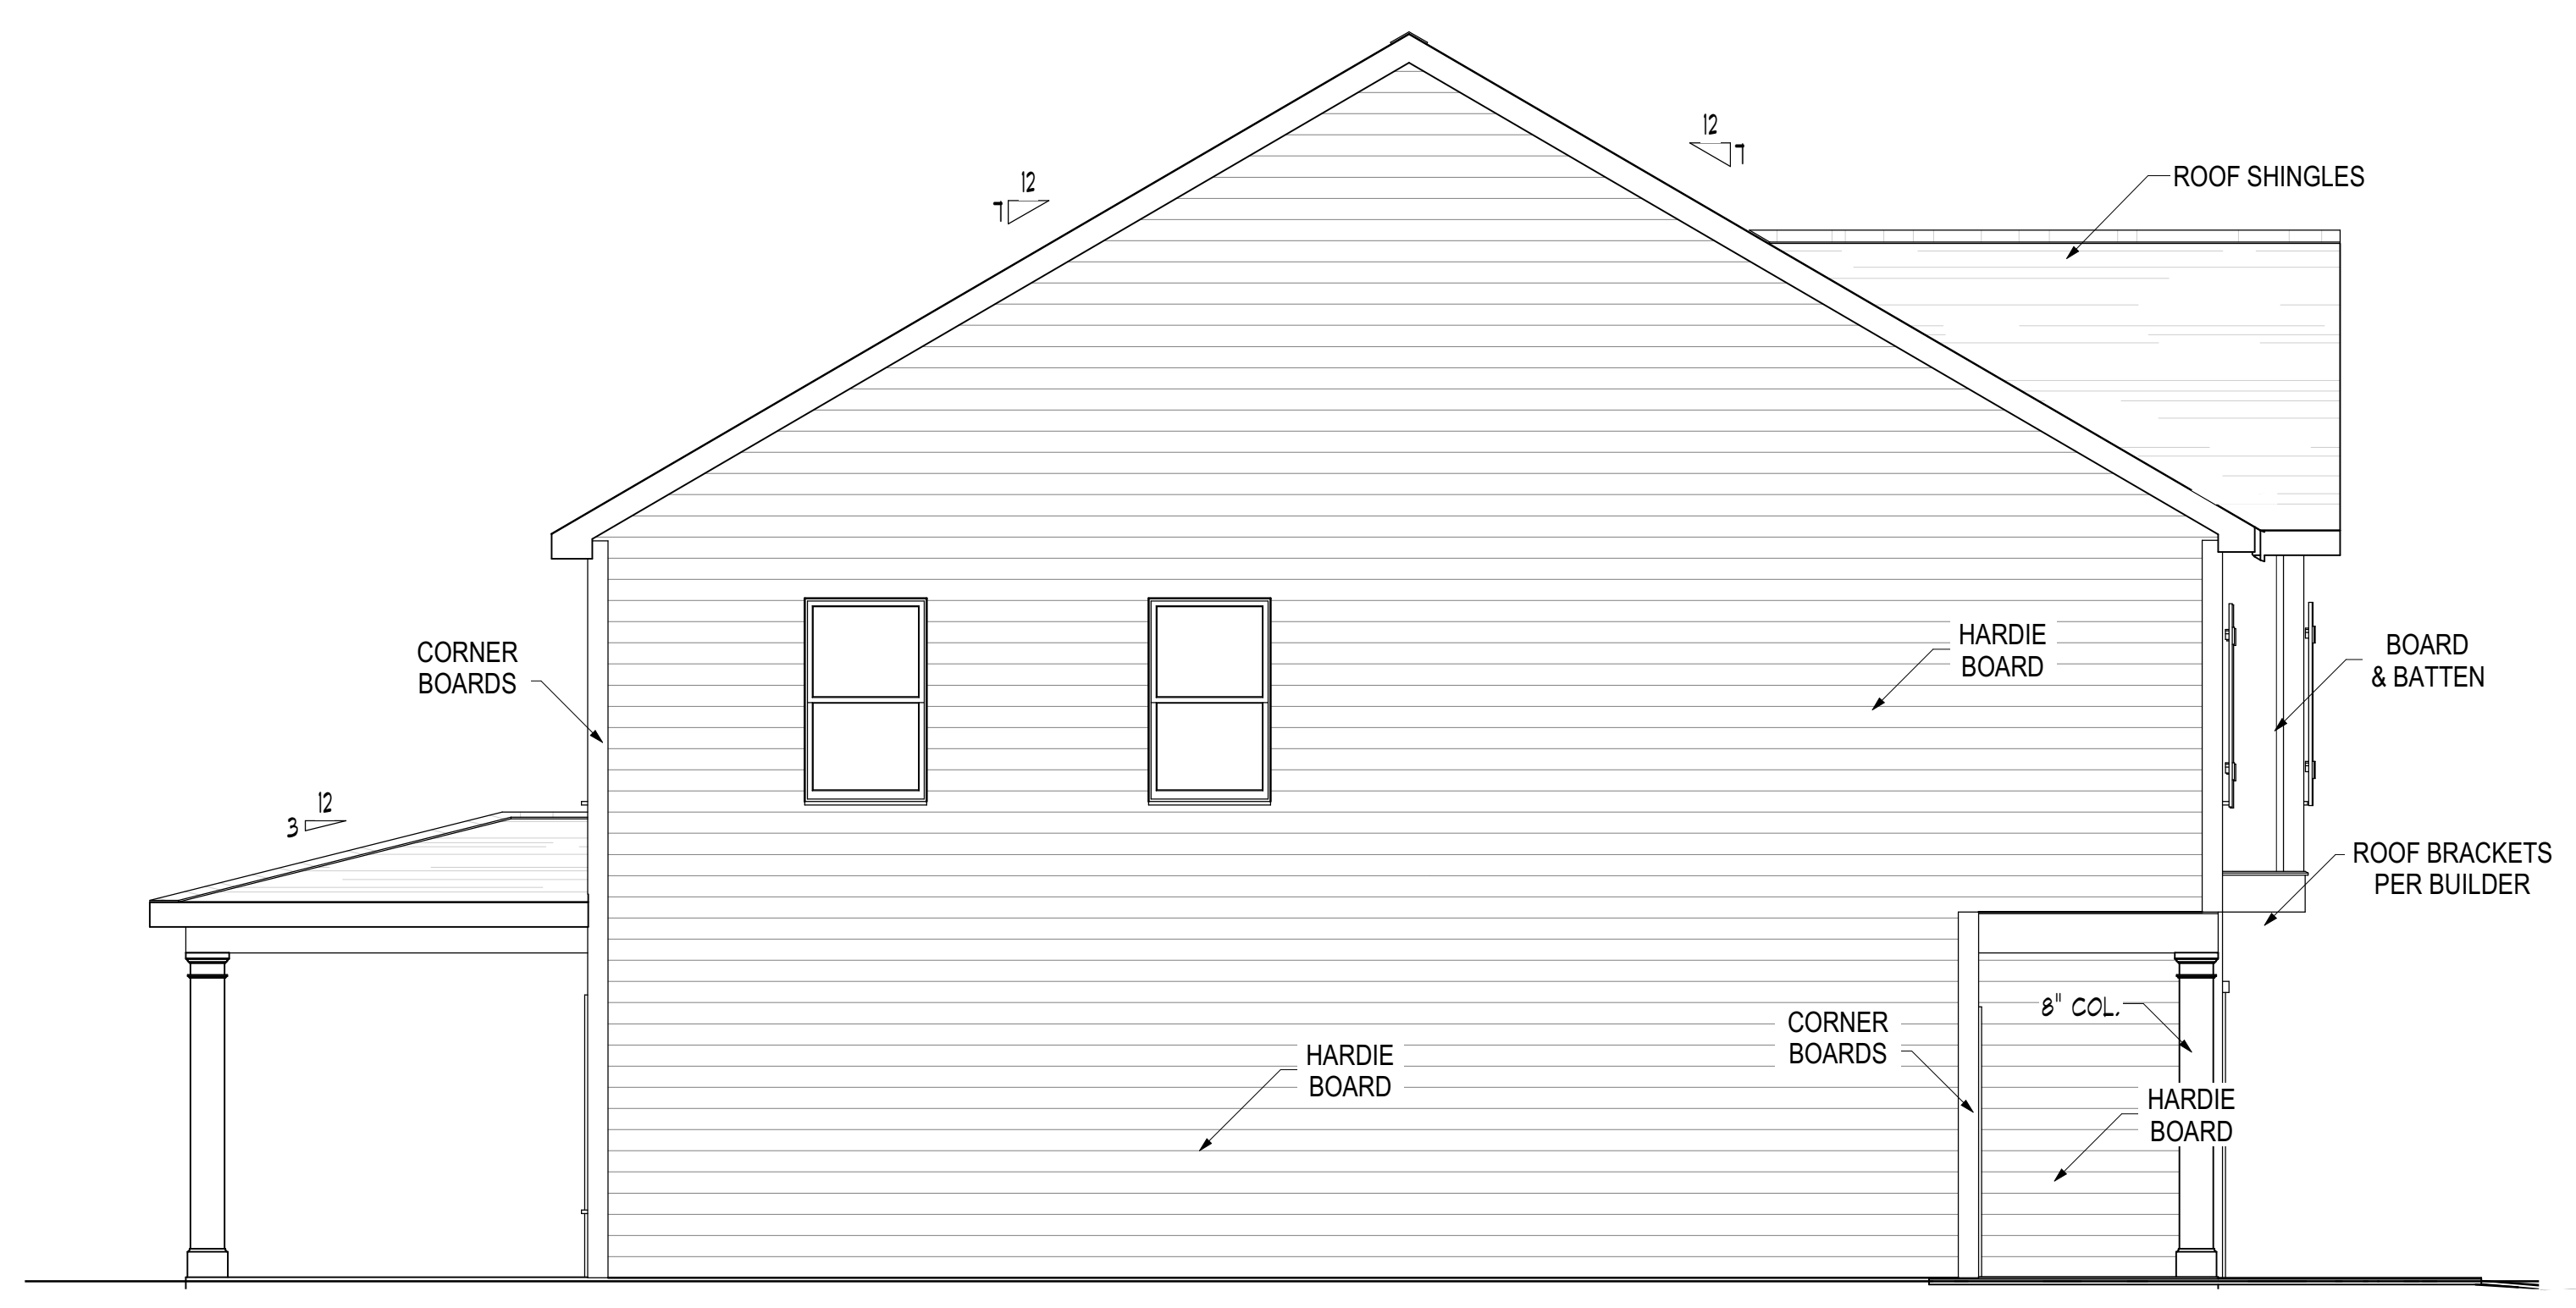

LEFT ELEVATION
SCALE 1/4" = 1'-0"

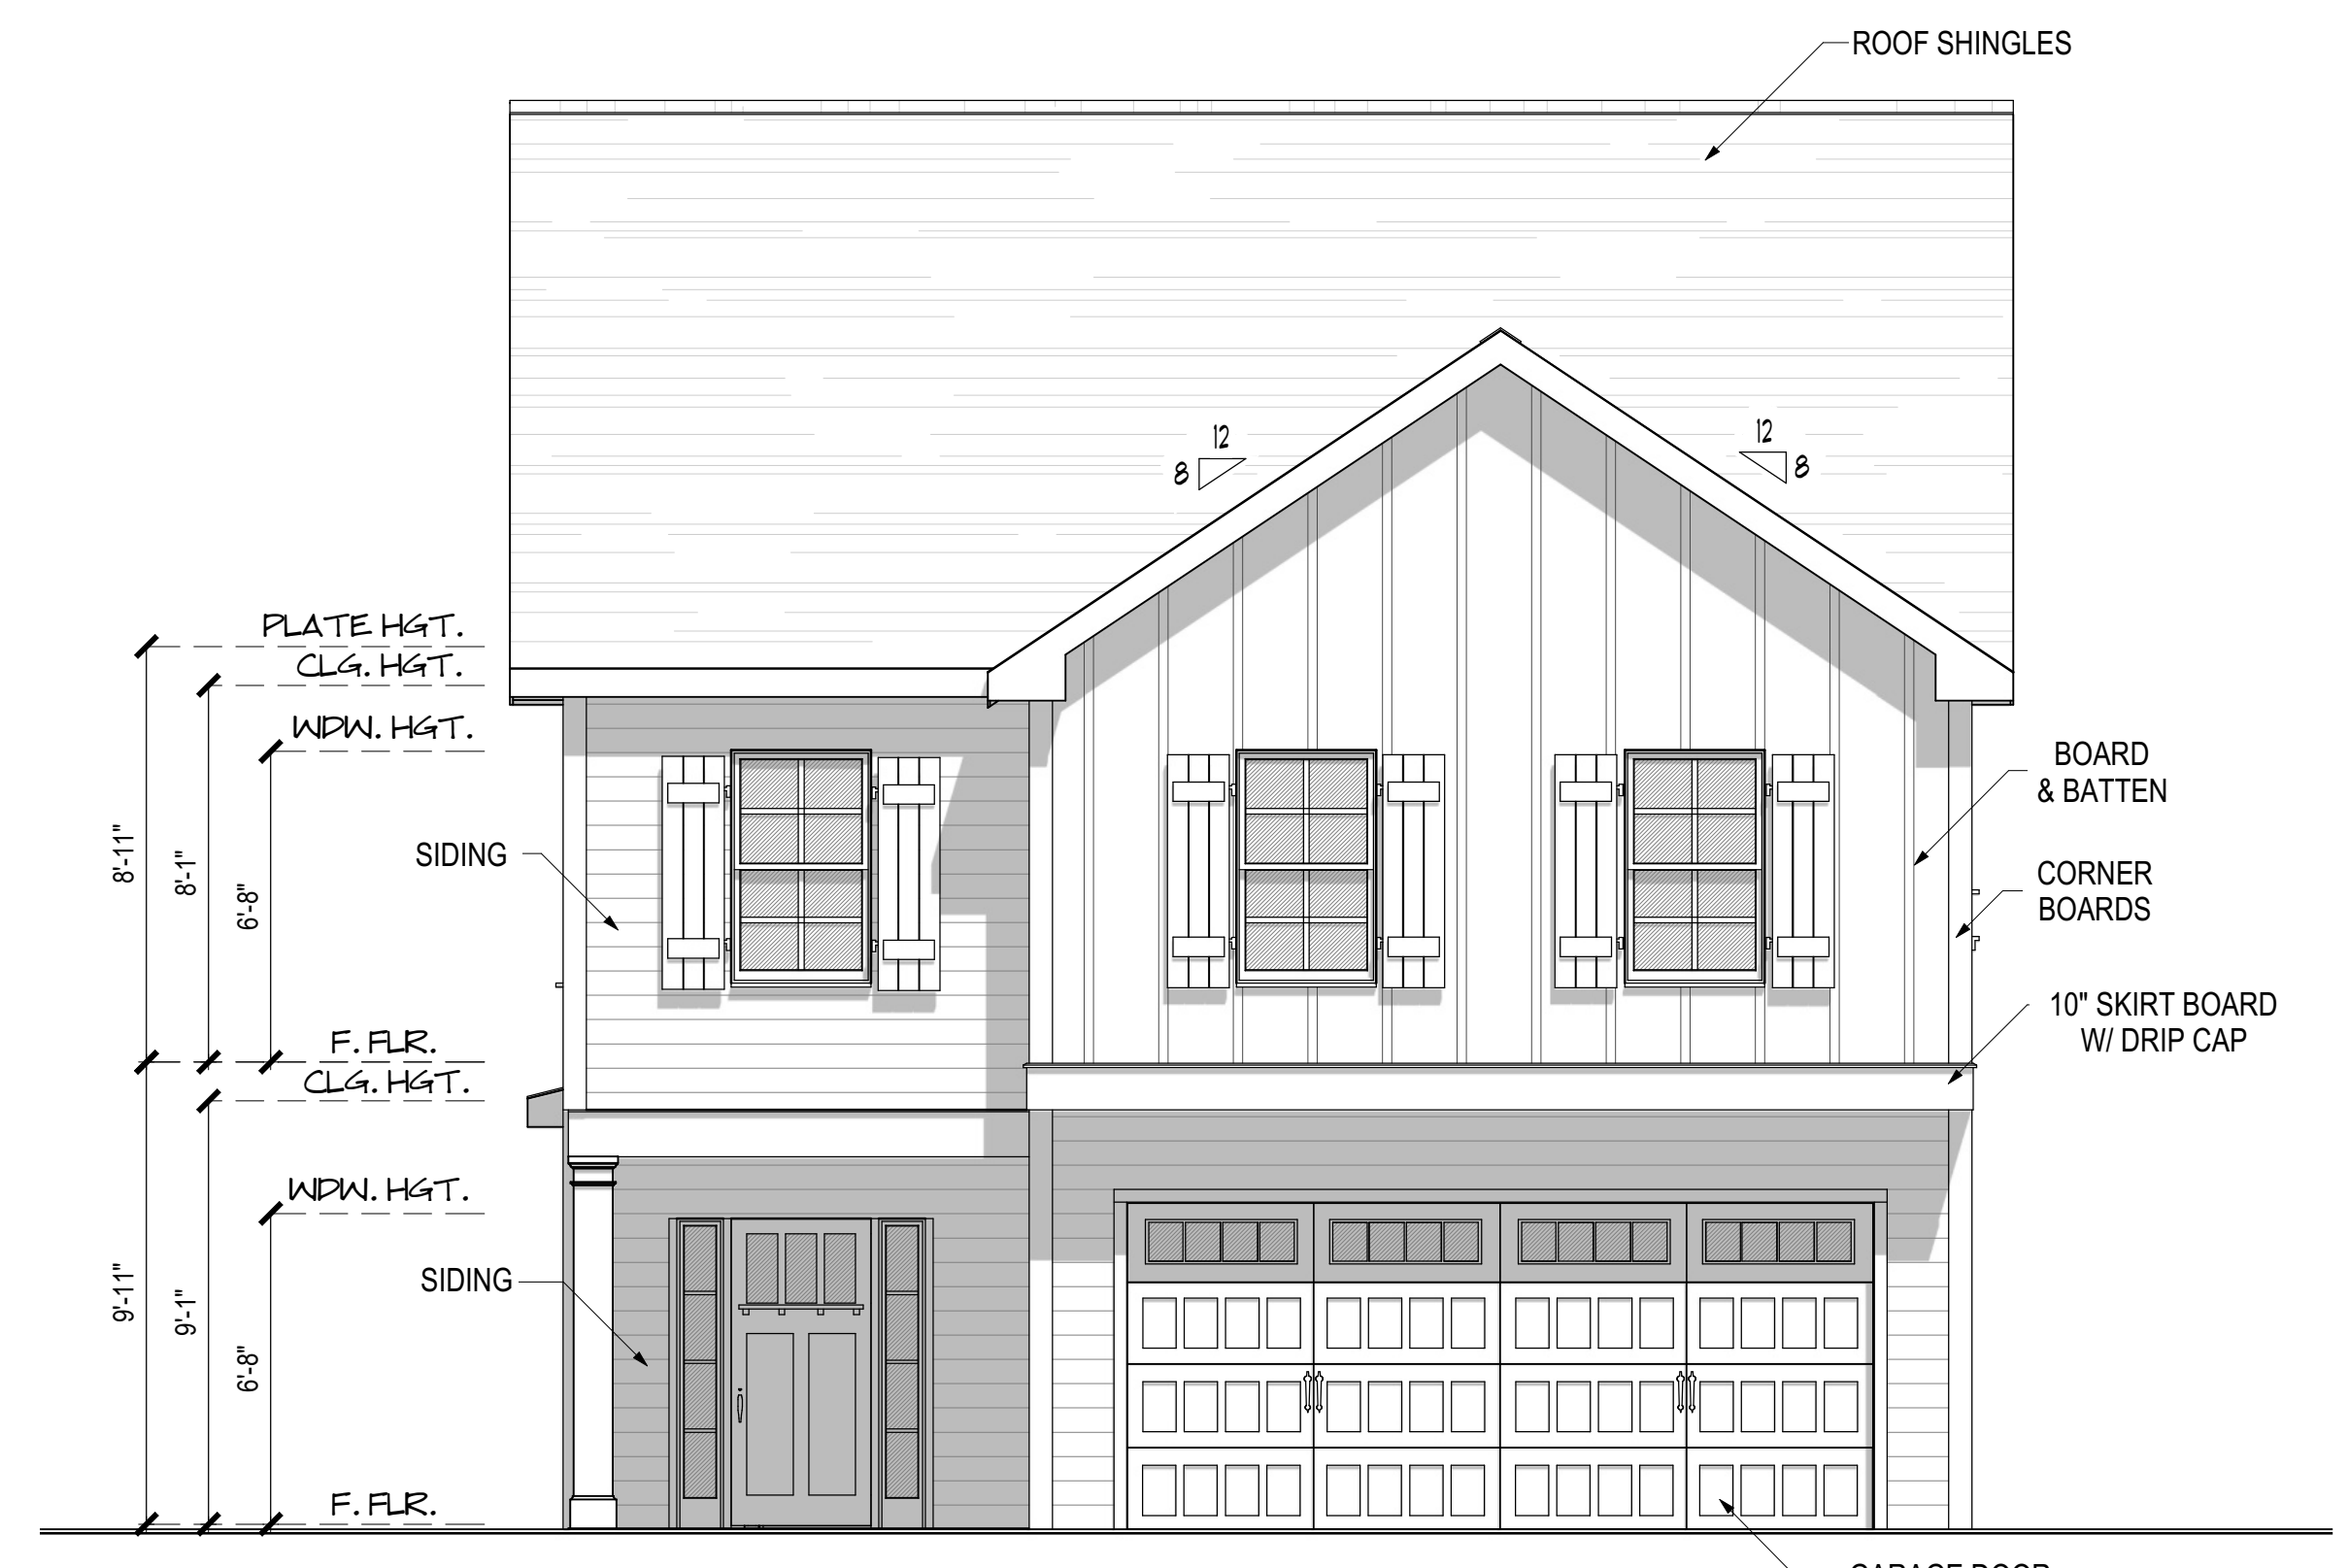


FRONT ELEVATION
SCALE 1/4" = 1'-0"

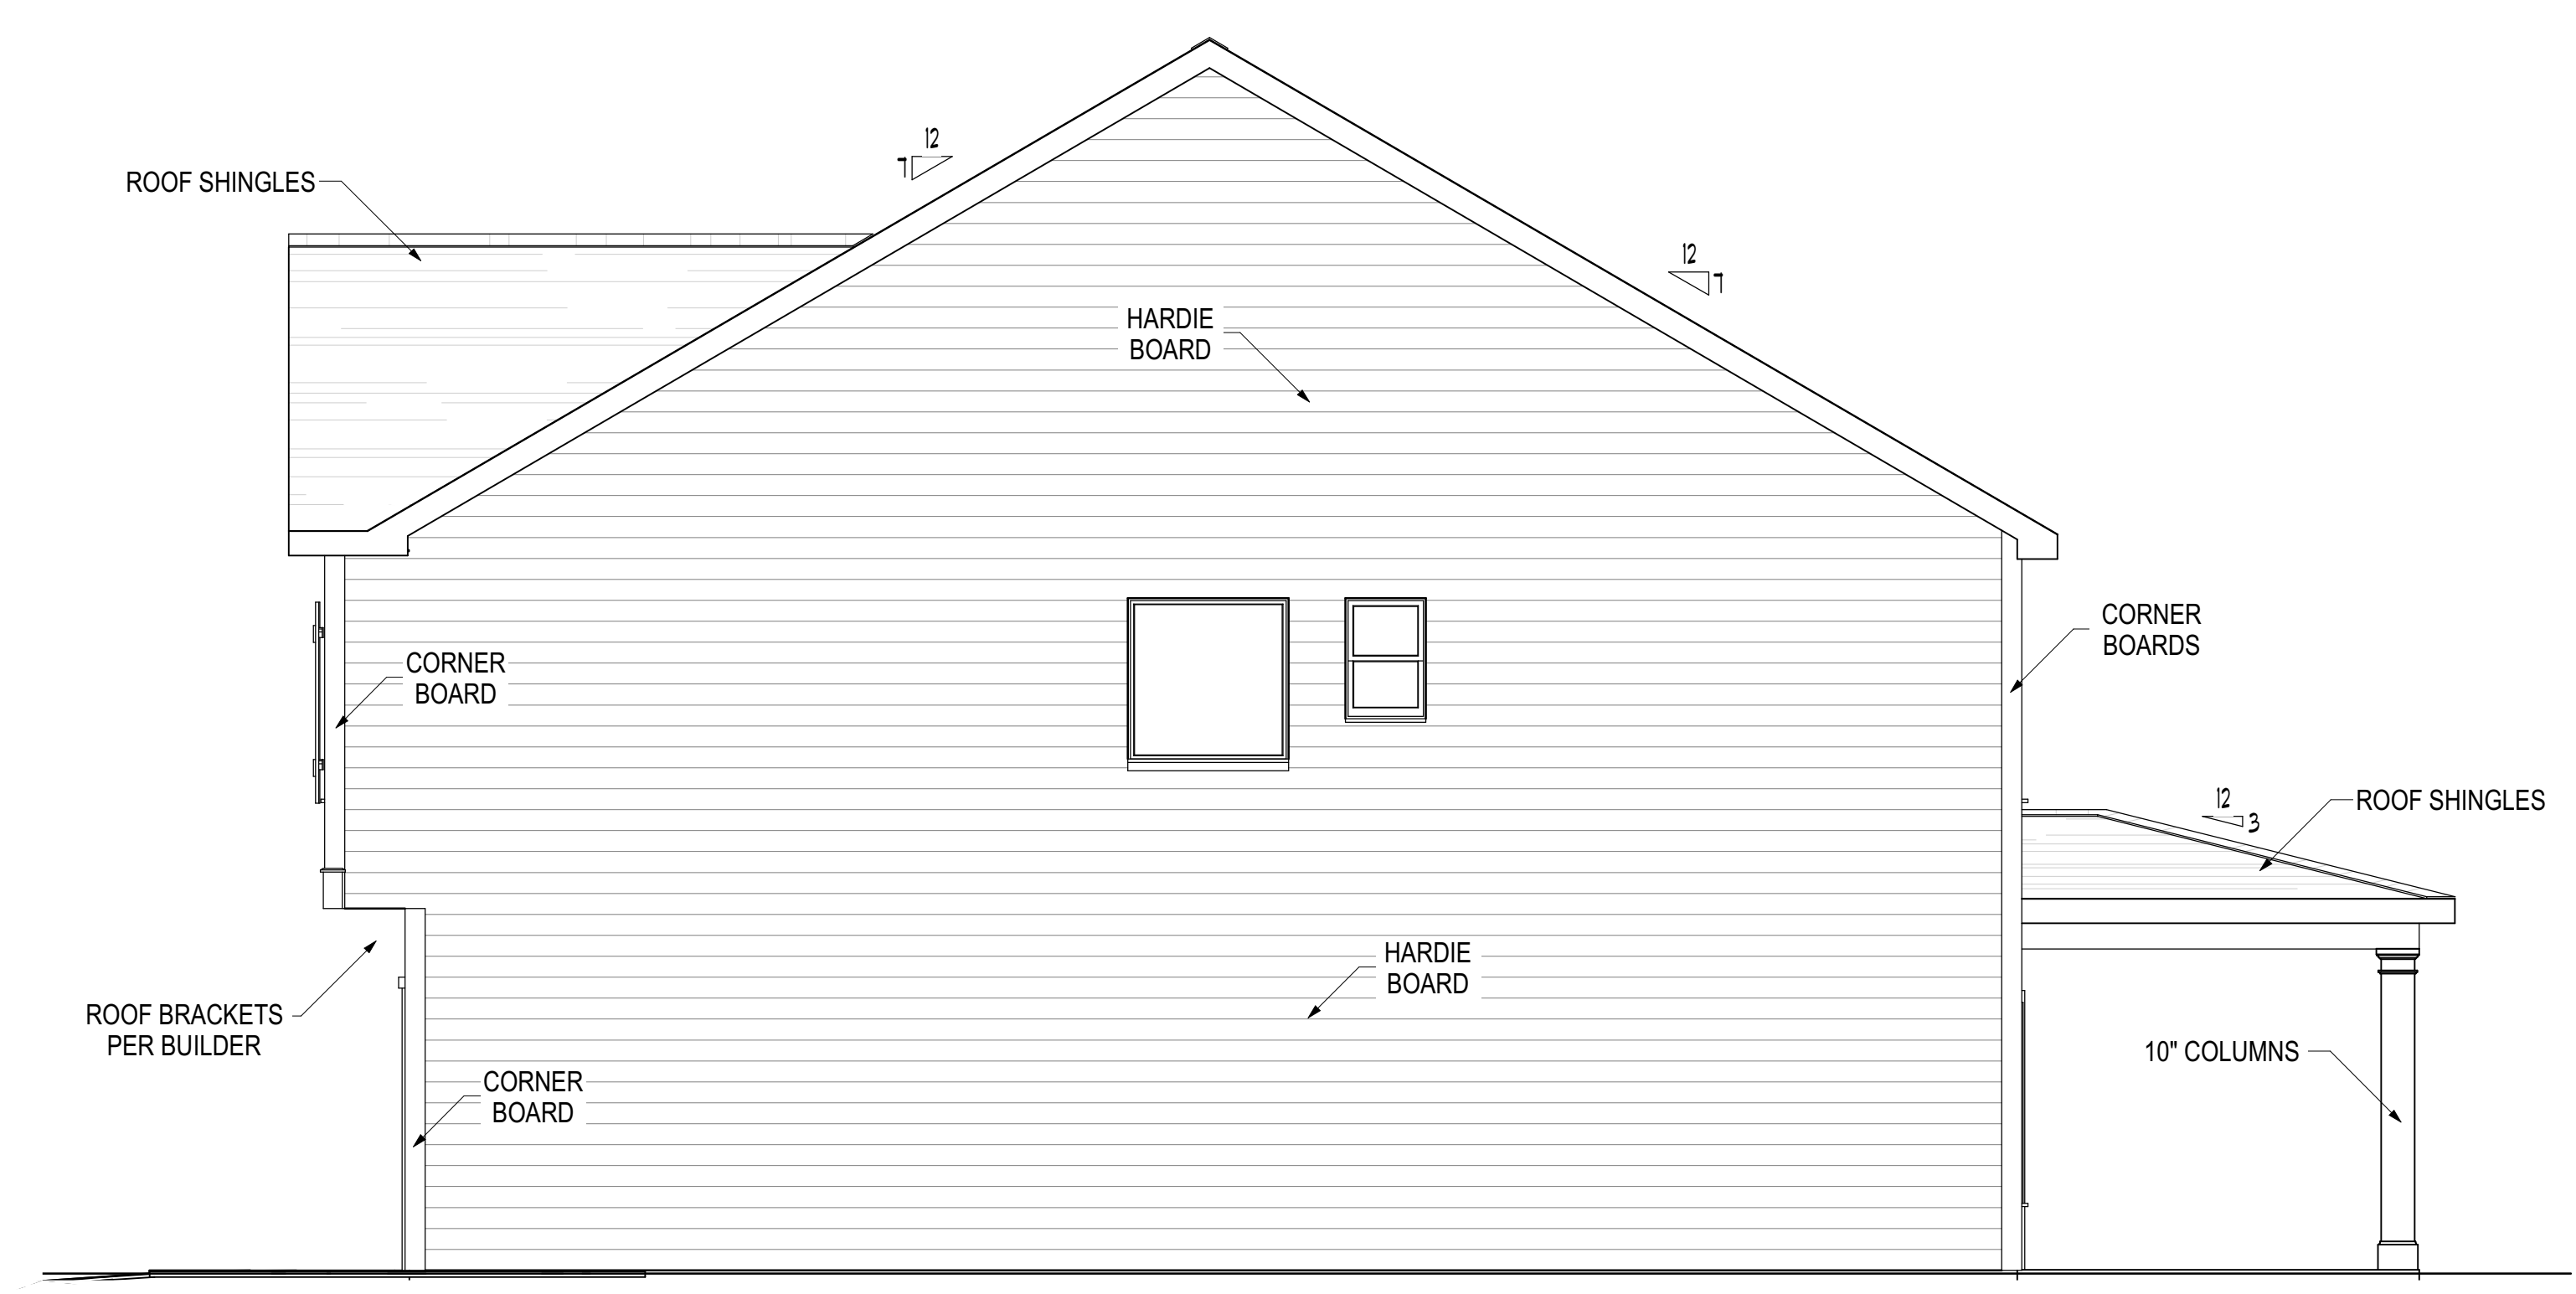


RIGHT ELEVATION
SCALE 1/4" = 1'-0"



REAR ELEVATION
SCALE 1/4" = 1'-0"

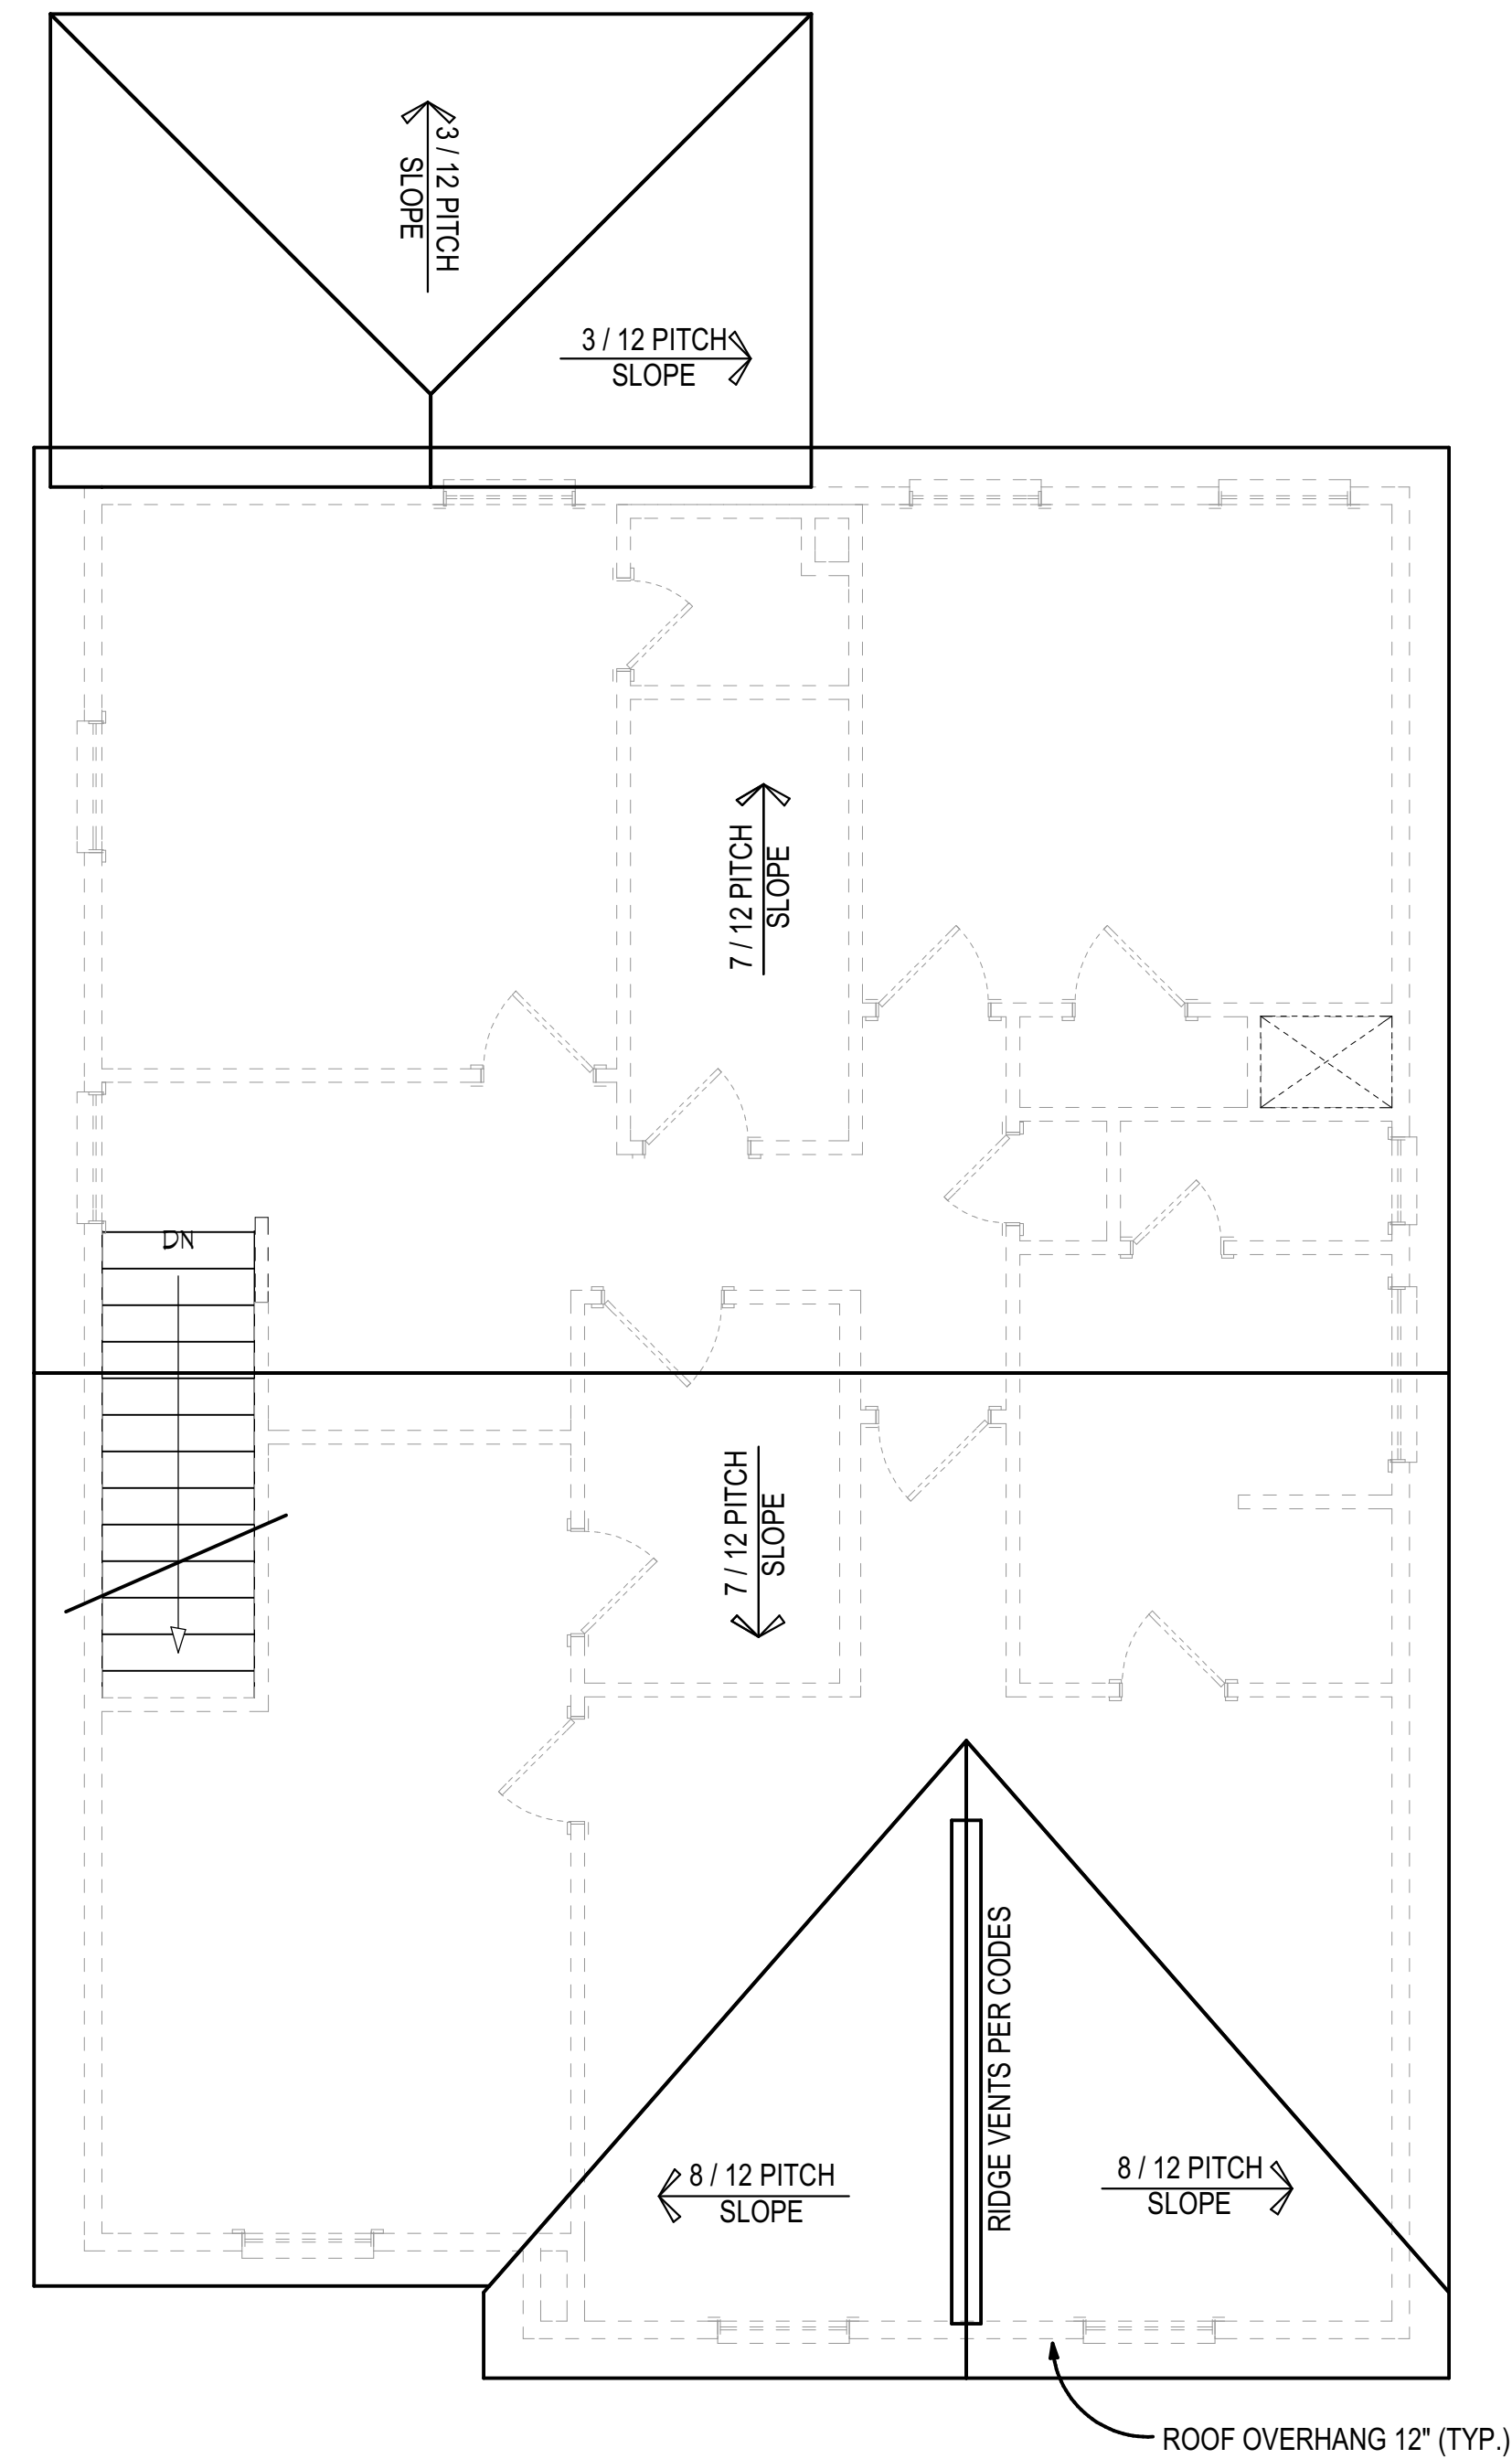

ROOF PLAN
SCALE 1/4" = 1'-0"

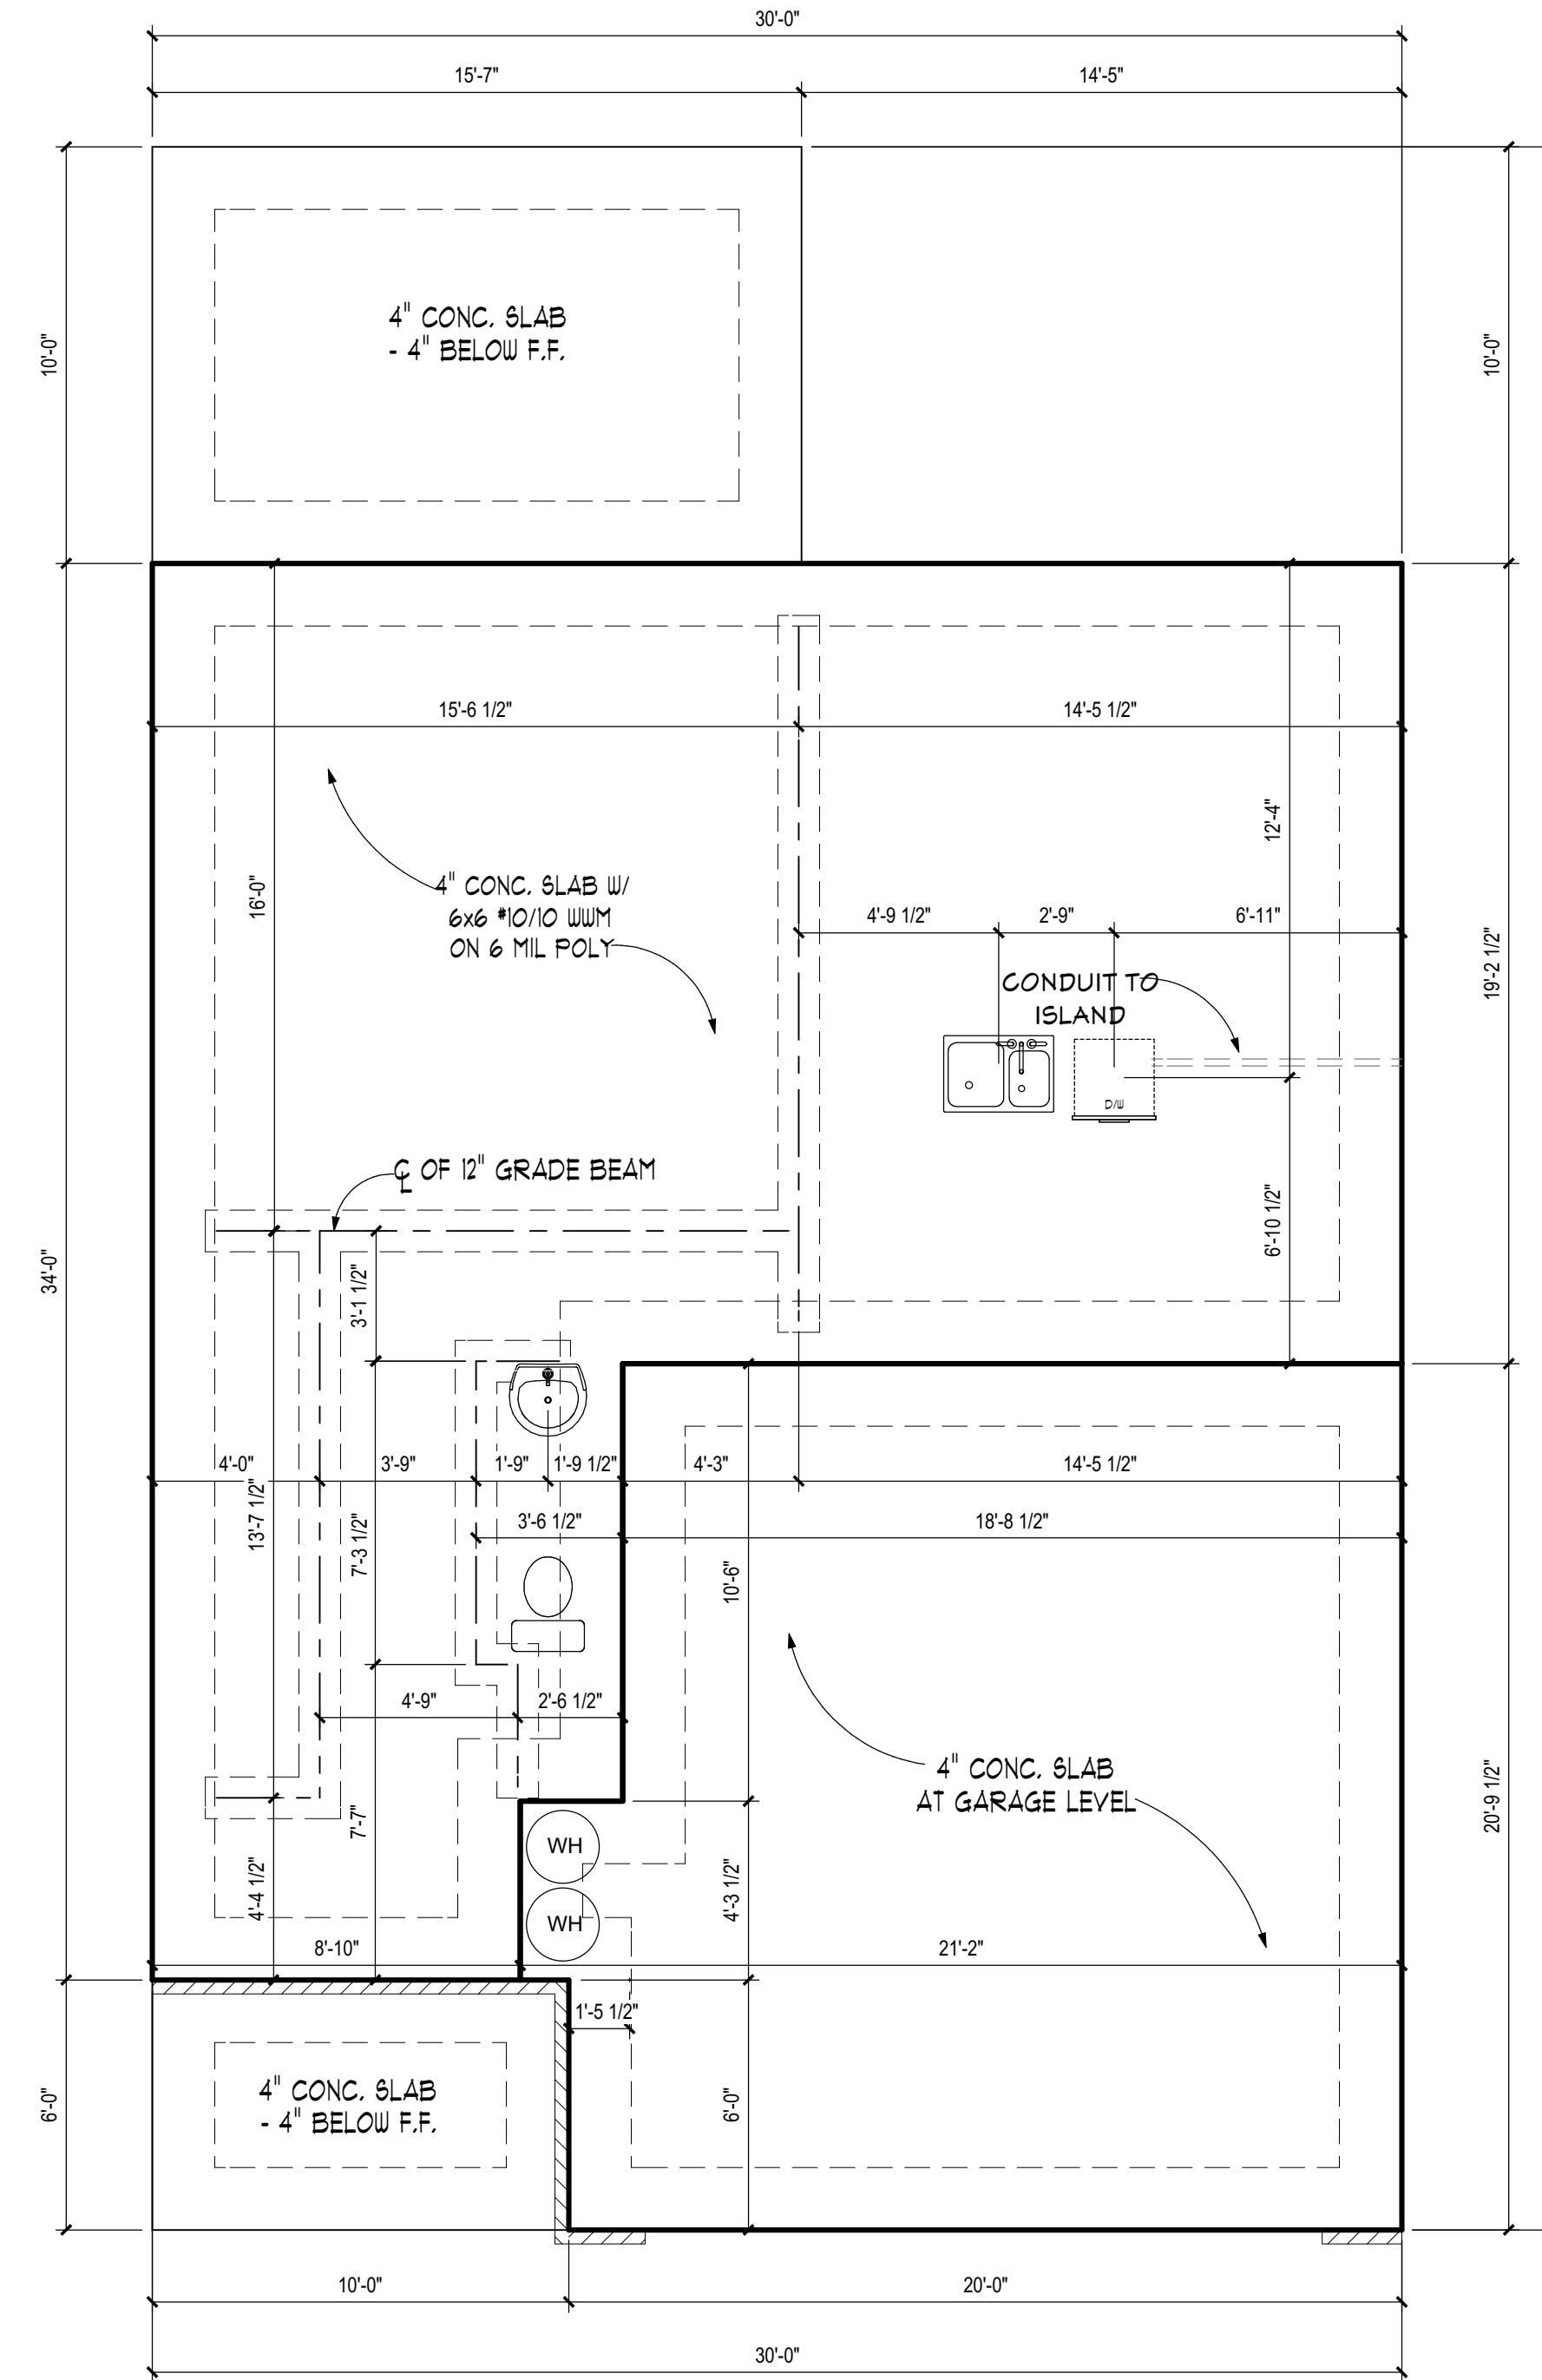

FOUNDATION PLAN
SCALE 1/4" = 1'-0"



PARAGON
HOME DESIGNS

809-A OAKHURST DR.
EVANS, G.A. 30809
OFFICE: 706-364-8554
FAX: 706-955-7945

Revision Table
Date Description

Date	Description

DAKOTA-GR
PROJECT DESCRIPTION:
FOREVER HOMES

DISCLAIMER NOTES:
TO the best of my knowledge these plans are drawn to comply with owner's and/ or builder's specifications and any changes made after prints are made and/ or approved will be done at the owner's and/or builder's expense and responsibility. The contractor shall verify enclosed drawing for builder and/or owner's standards. PARAGON HOME DESIGNS LLC. is not liable for design discrepancies once construction has begun. While every effort has been made in the preparation of this plan to avoid any oversights, the maker can not guarantee against human error. The contractor of the job must check all dimensions and other details prior to construction and be solely responsible thereafter.

A-2

SHEET # 2 OF 4

SCALE: AS NOTED
DATE PRINTED: 2/29/2024



PARAGON
HOME DESIGNS

809-A OAKHURST DR.
EVANS, G.A. 30809
OFFICE: 706-364-8554
FAX: 706-955-7945

Revision Table	
Date	Description


DAKOTA-GR
 PROJECT DESCRIPTION:
 FOREVER HOMES

DISCLAIMER NOTES:
 TO the best of my knowledge these plans are drawn to comply with owner's and/ or builder's specifications and any changes made after prints are made and/ or approved will be done at the owner's and/or builder's expense and responsibility. The contractor shall verify enclosed drawing for builder and/or owner's standards. PARAGON HOME DESIGNS LLC. is not liable for design discrepancies once construction has begun. While every effort has been made in the preparation of this plan to avoid any oversights, the maker can not guarantee against human error. The contractor of the job must check all dimensions and other details prior to construction and be solely responsible thereafter.


A-3

SHEET # 3 OF 4

SCALE: AS NOTED
 DATE PRINTED: 2/29/2024

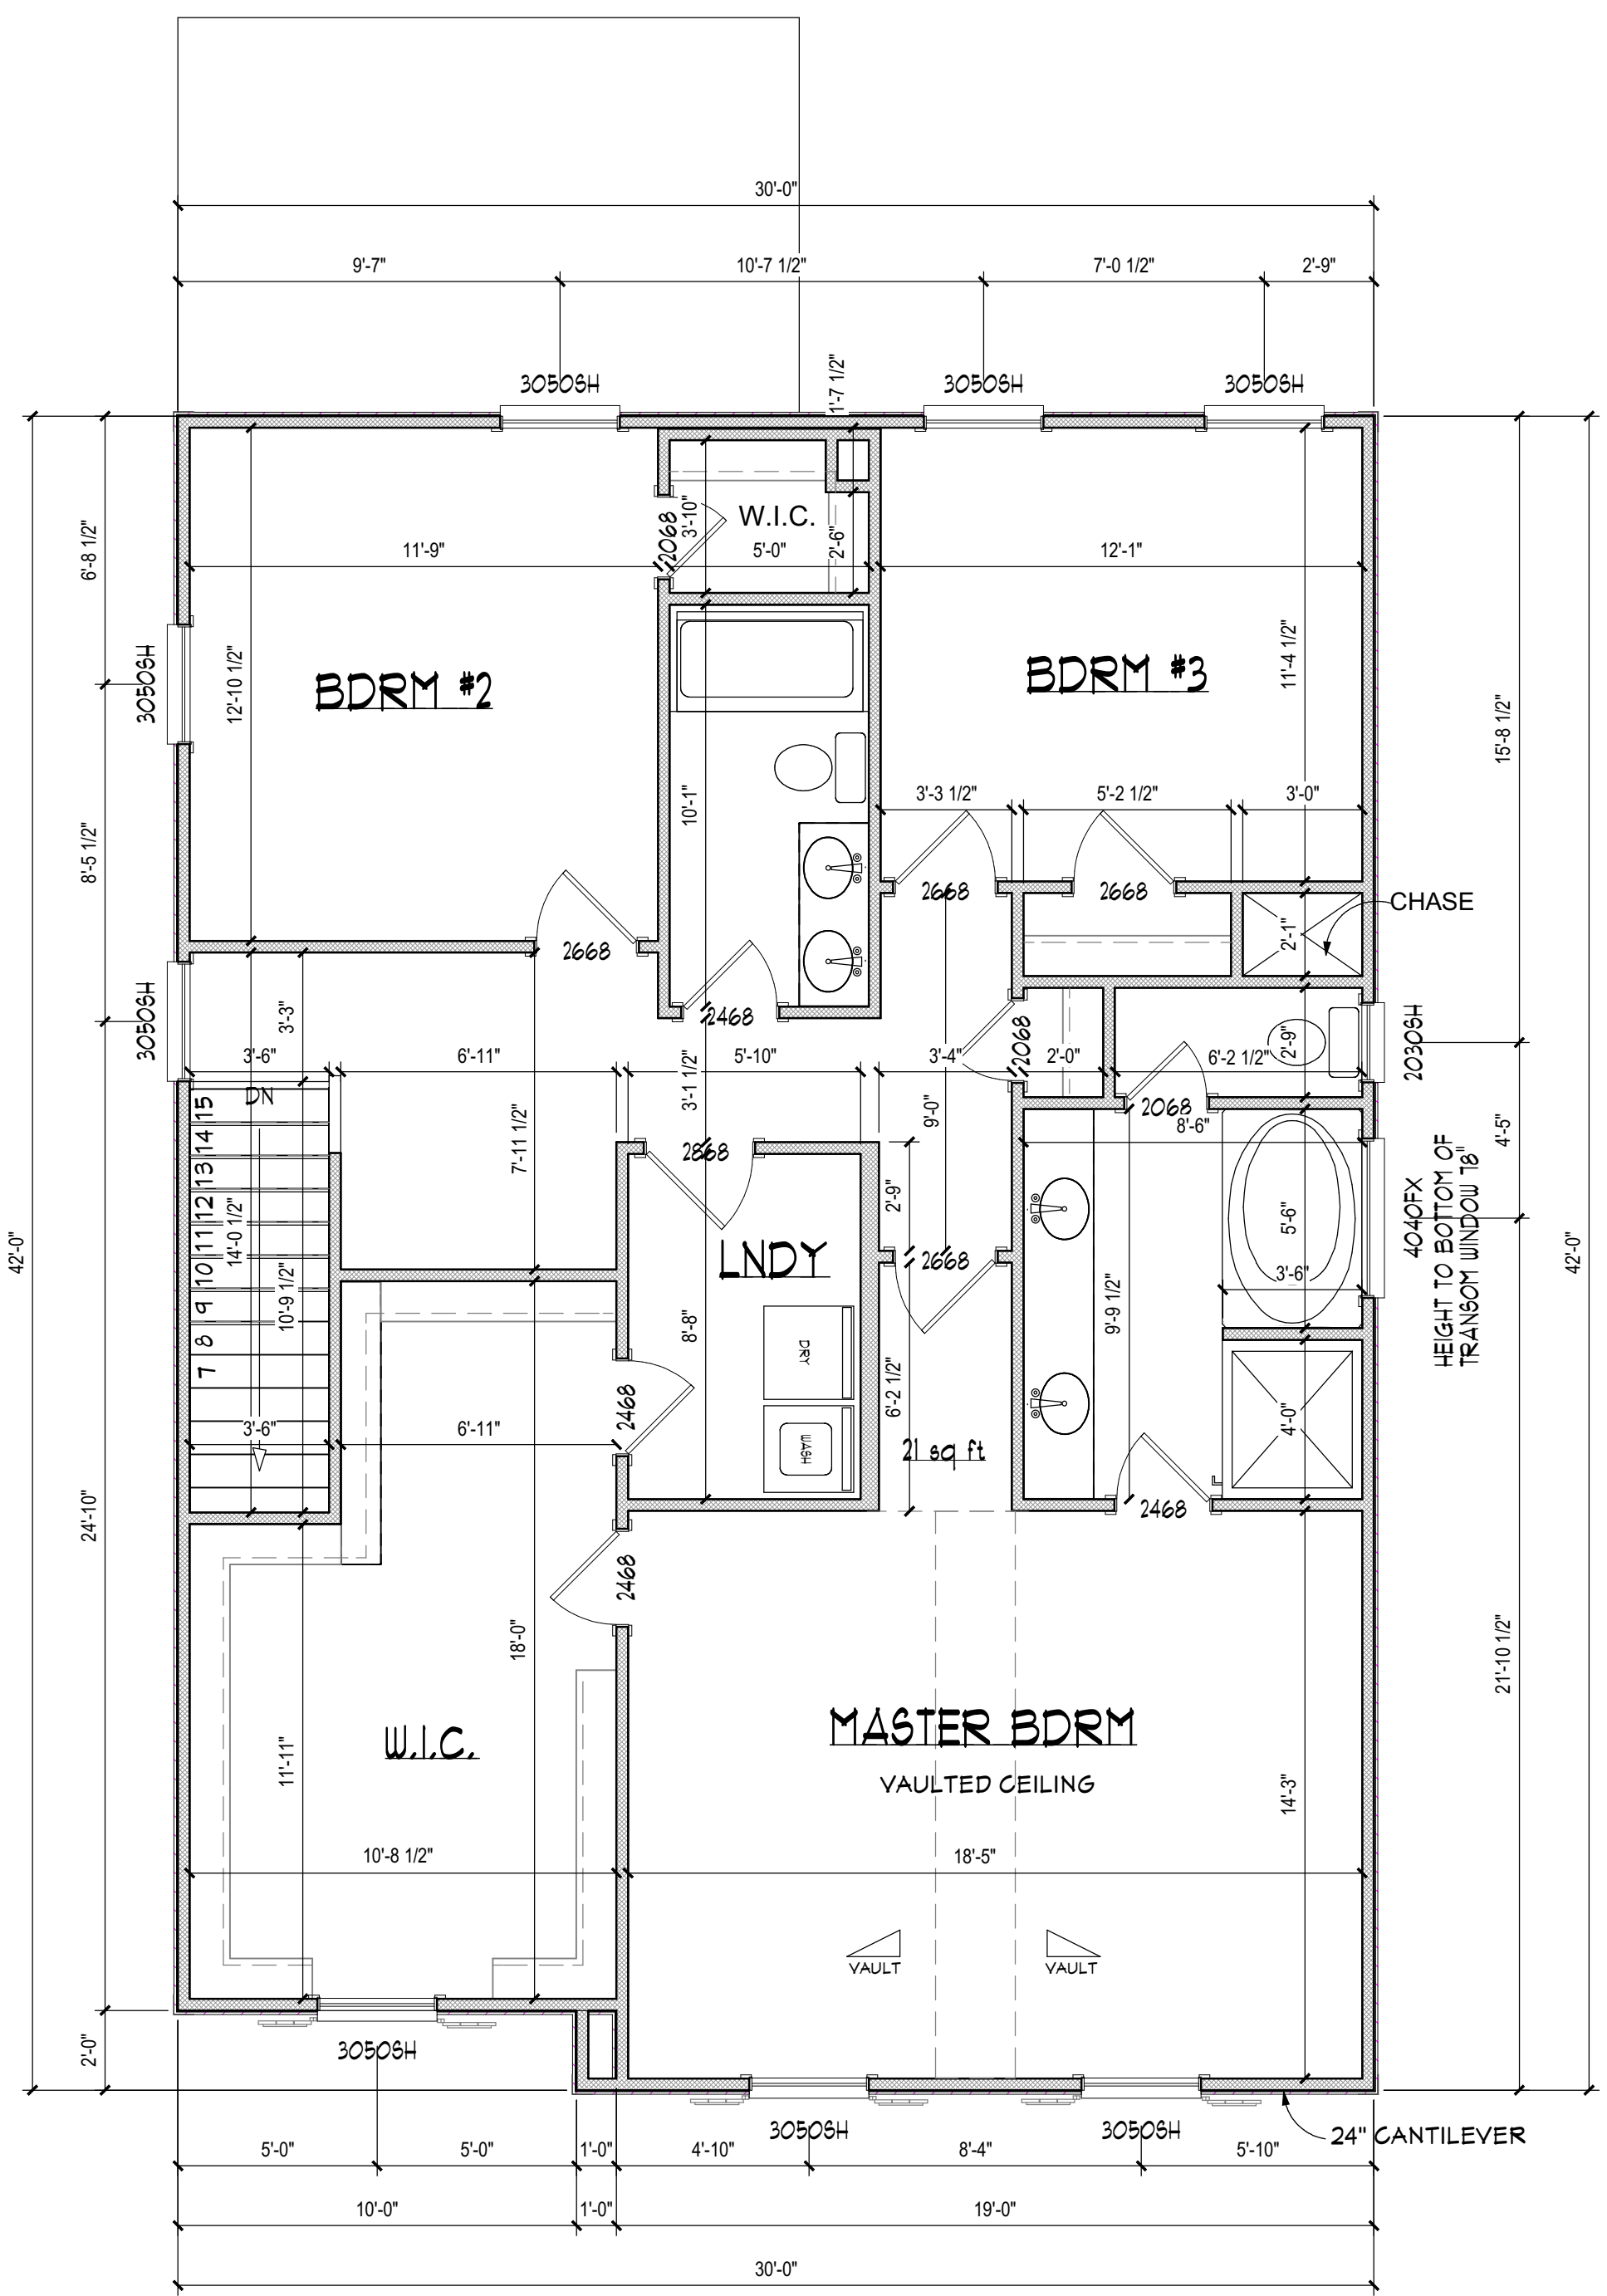

SECOND FLOORPLAN
 SCALE 1/4" = 1'-0"
 1213 sq ft

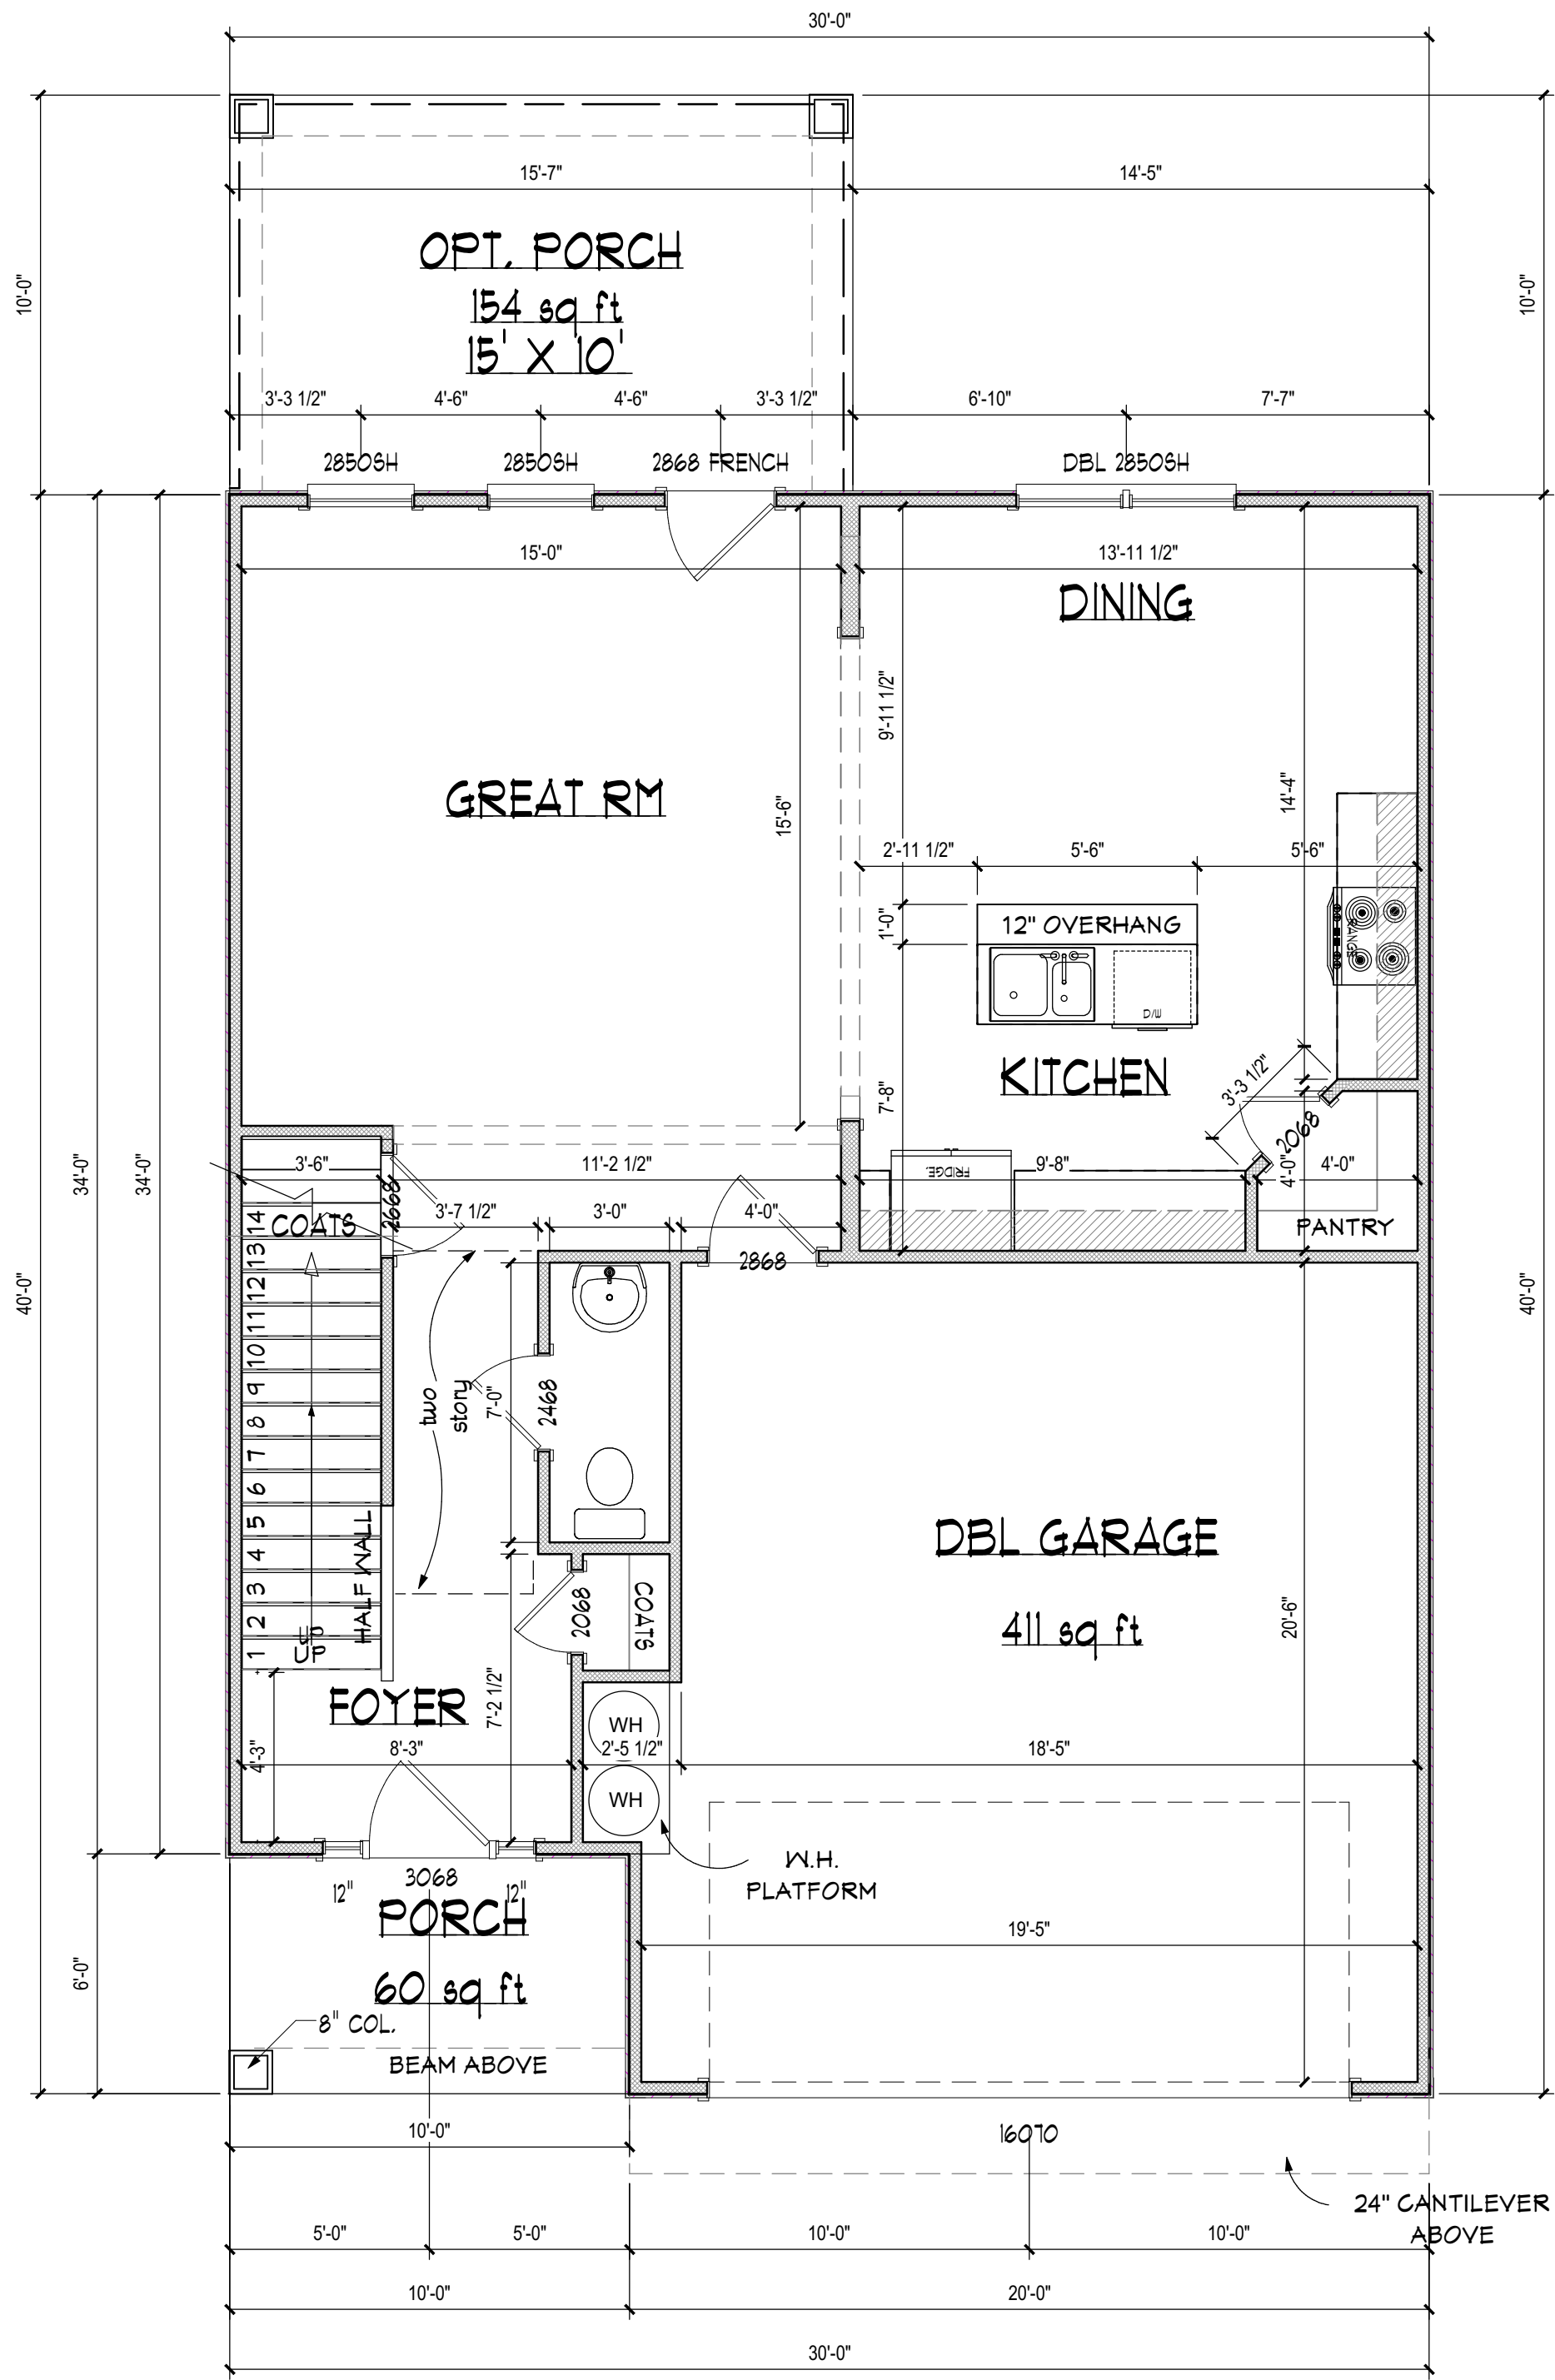

FIRST FLOORPLAN
 SCALE 1/4" = 1'-0"
 742 sq ft

ESTIMATED SQUARE FOOTAGE	
FIRST FLOOR HTD.	731 SQ. FT.
SECOND FLOOR HTD.	1213 SQ. FT.
TOTAL HTD.	1950 SQ. FT.
FRONT PORCH	58 SQ. FT.
OPT. REAR PORCH	154 SQ. FT.
GARAGE	421 SQ. FT.
TOTAL	2990 SQ. FT.



PARAGON
HOME DESIGNS


809-A OAKHURST DR.
EVANS, G.A. 30809
OFFICE: 706-364-8554
FAX: 706-955-7945

Revision Table	
Date	Description

DAKOTA-GR
PROJECT DESCRIPTION:
FOREVER HOMES

DISCLAIMER NOTES:
TO the best of my knowledge these plans are drawn to comply with owner's and/ or builder's specifications and any changes made after prints are made and/ or approved will be done at the owner's and/or builder's expense and responsibility. The contractor shall verify enclosed drawing for builder and/or owner's standards. PARAGON HOME DESIGNS LLC. is not liable for design discrepancies once construction has begun. While every effort has been made in the preparation of this plan to avoid any oversights, the maker can not guarantee against human error. The contractor of the job must check all dimensions and other details prior to construction and be solely responsible thereafter.


A-4
SHEET # 4 OF 4
SCALE: AS NOTED
DATE PRINTED: 2/29/2024

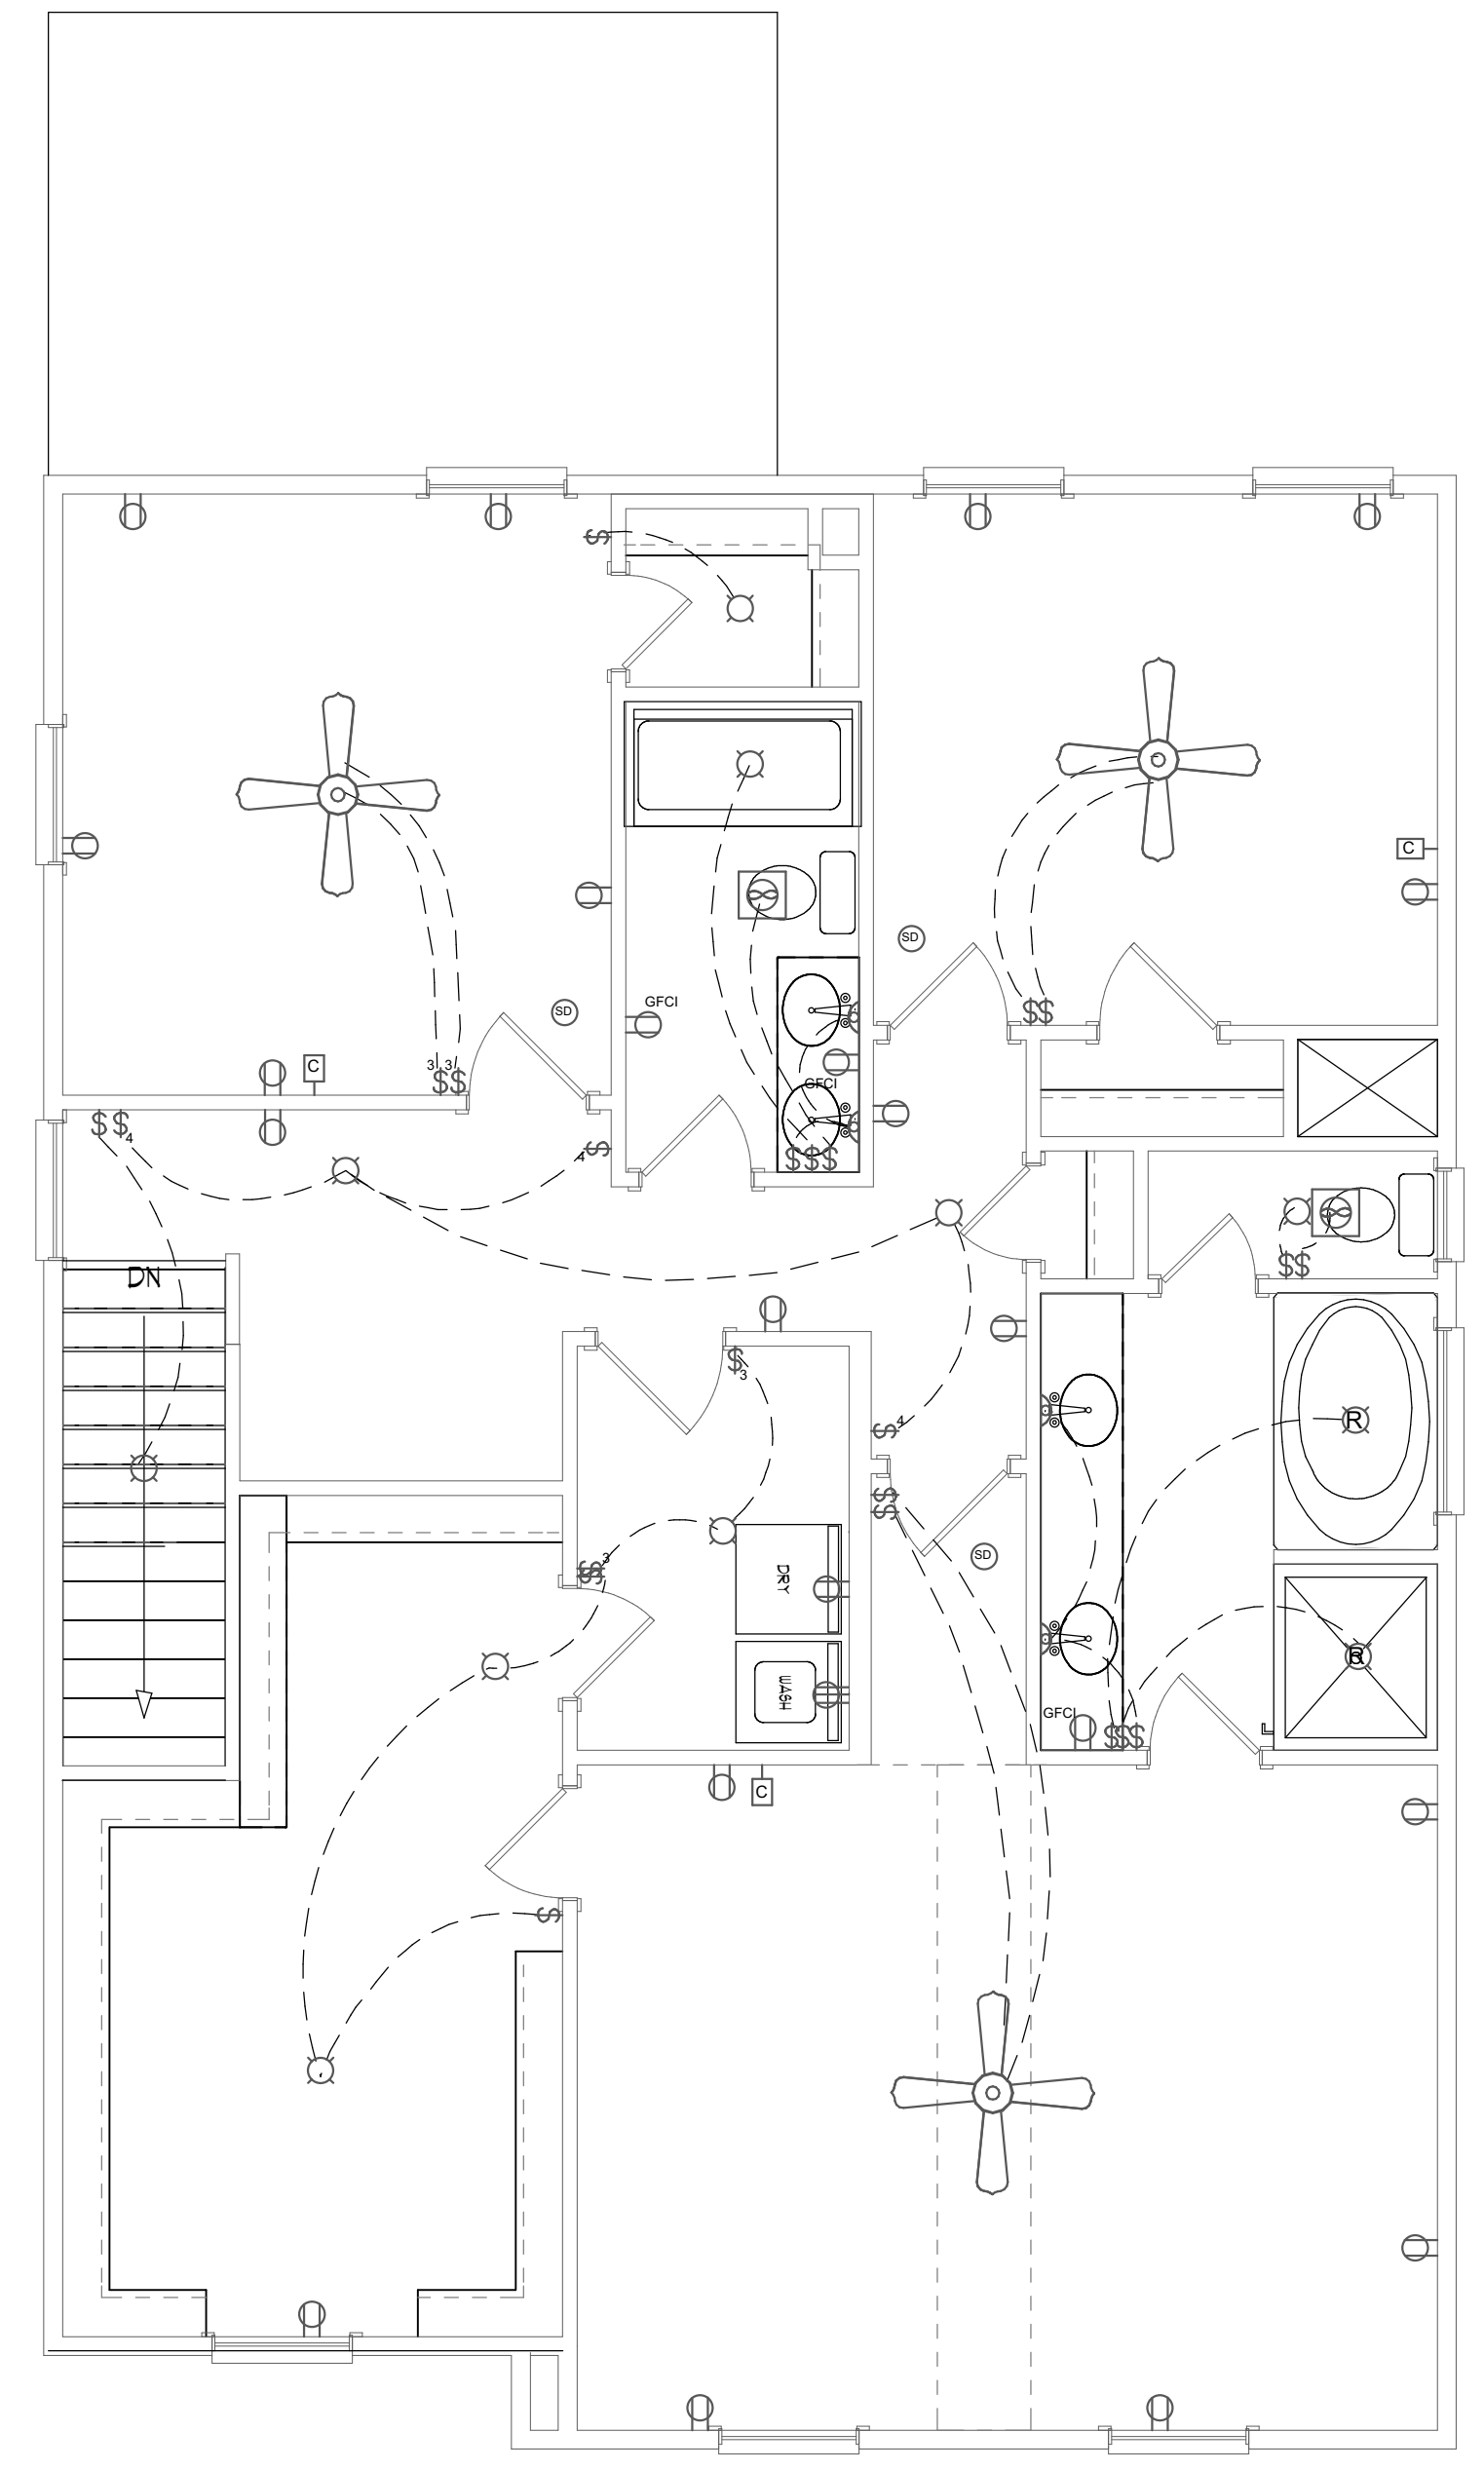

ELECTRICAL PLAN
SCALE 1/4" - 1'-0"

ELECTRICAL LEGEND

SYMBOL	DESCRIPTION	SYMBOL	DESCRIPTION
	CEILING FAN W/ LIGHT		EXHAUST FAN
	FLUORESCENT LIGHT FIXTURE		110V DUPLEX RECEPTACLE
	CHANDELLER LIGHTING		110V DUPLEX RECEPTACLE GROUND FAULT INTERRUPTED
	PENDANT LIGHTING		110V DUPLEX RECEPTACLE W/ WEATHERPROOF COVER
	110V CEILING LIGHT FIXTURE		240V RECEPTACLE
	110V RECESSED LIGHT FIXTURE		TELEPHONE JACKS
	SINGLE POLE SWITCH		TELEVISION JACKS
	OUTDOOR SWITCH		SMOKE DETECTOR

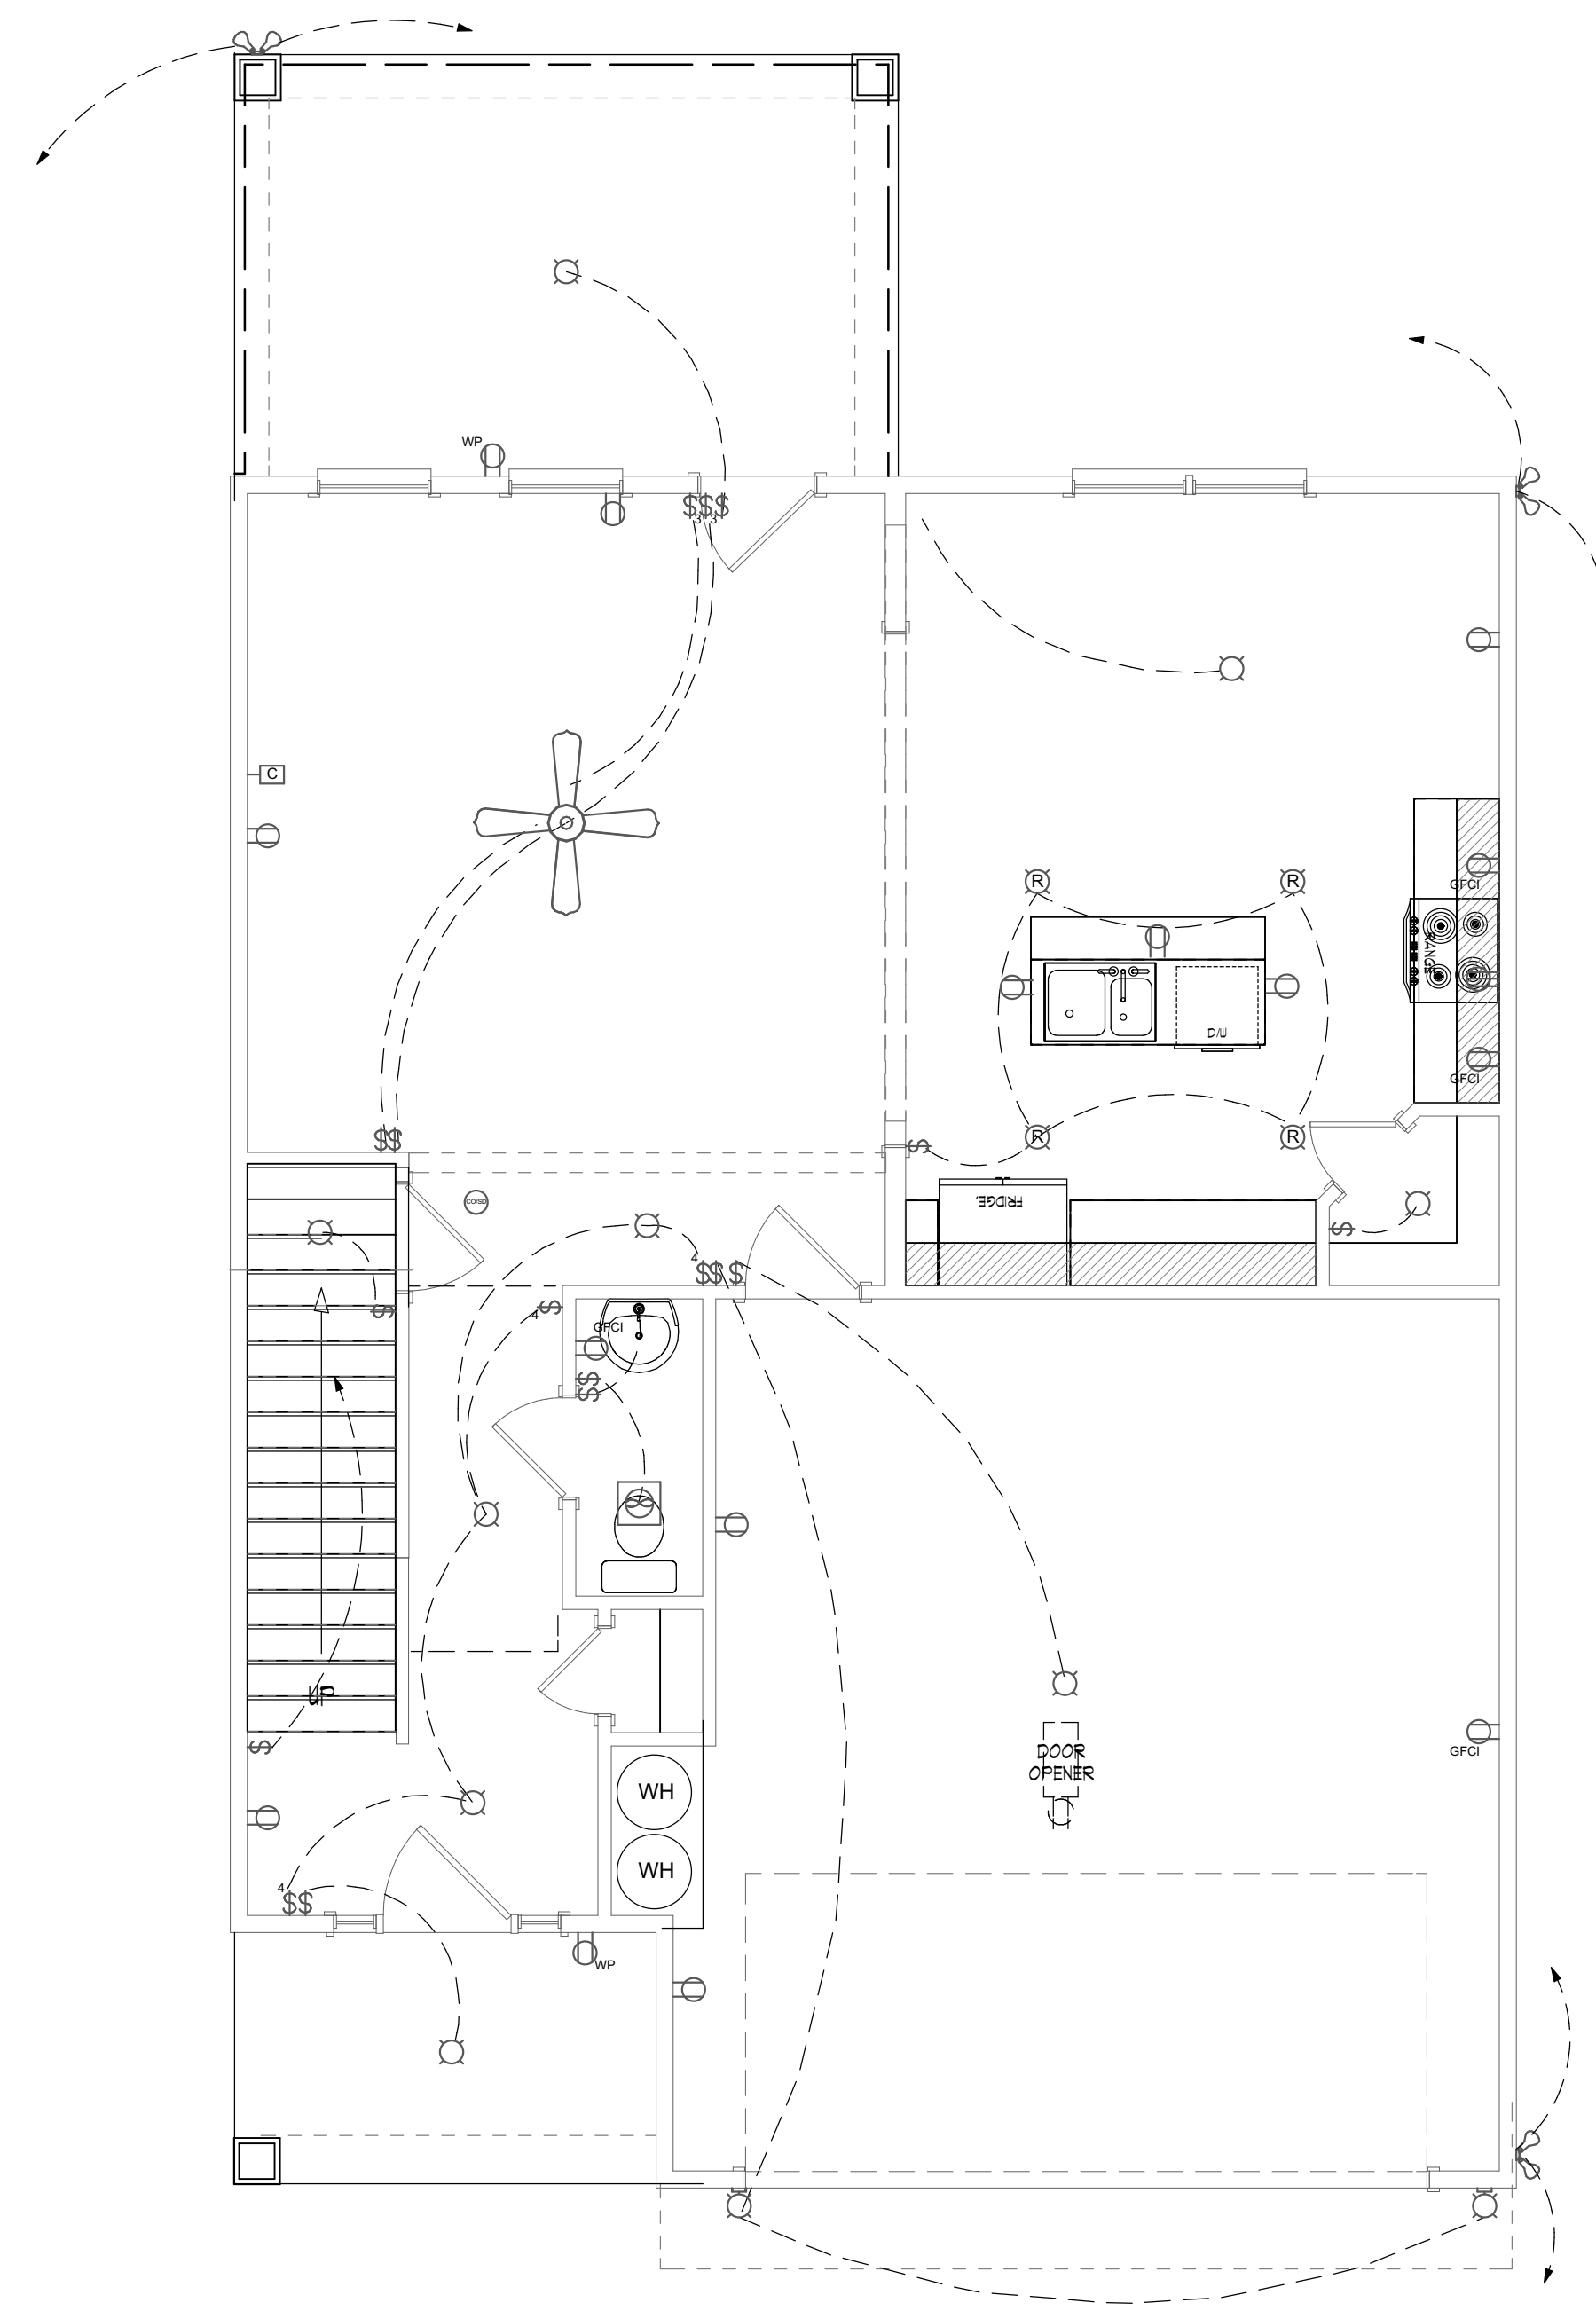

ELECTRICAL PLAN
SCALE 1/4" - 1'-0"